


DO NOT SCALE

Front Quad
Ground Floor

St Peter in the East
Churchyard

new college gardens

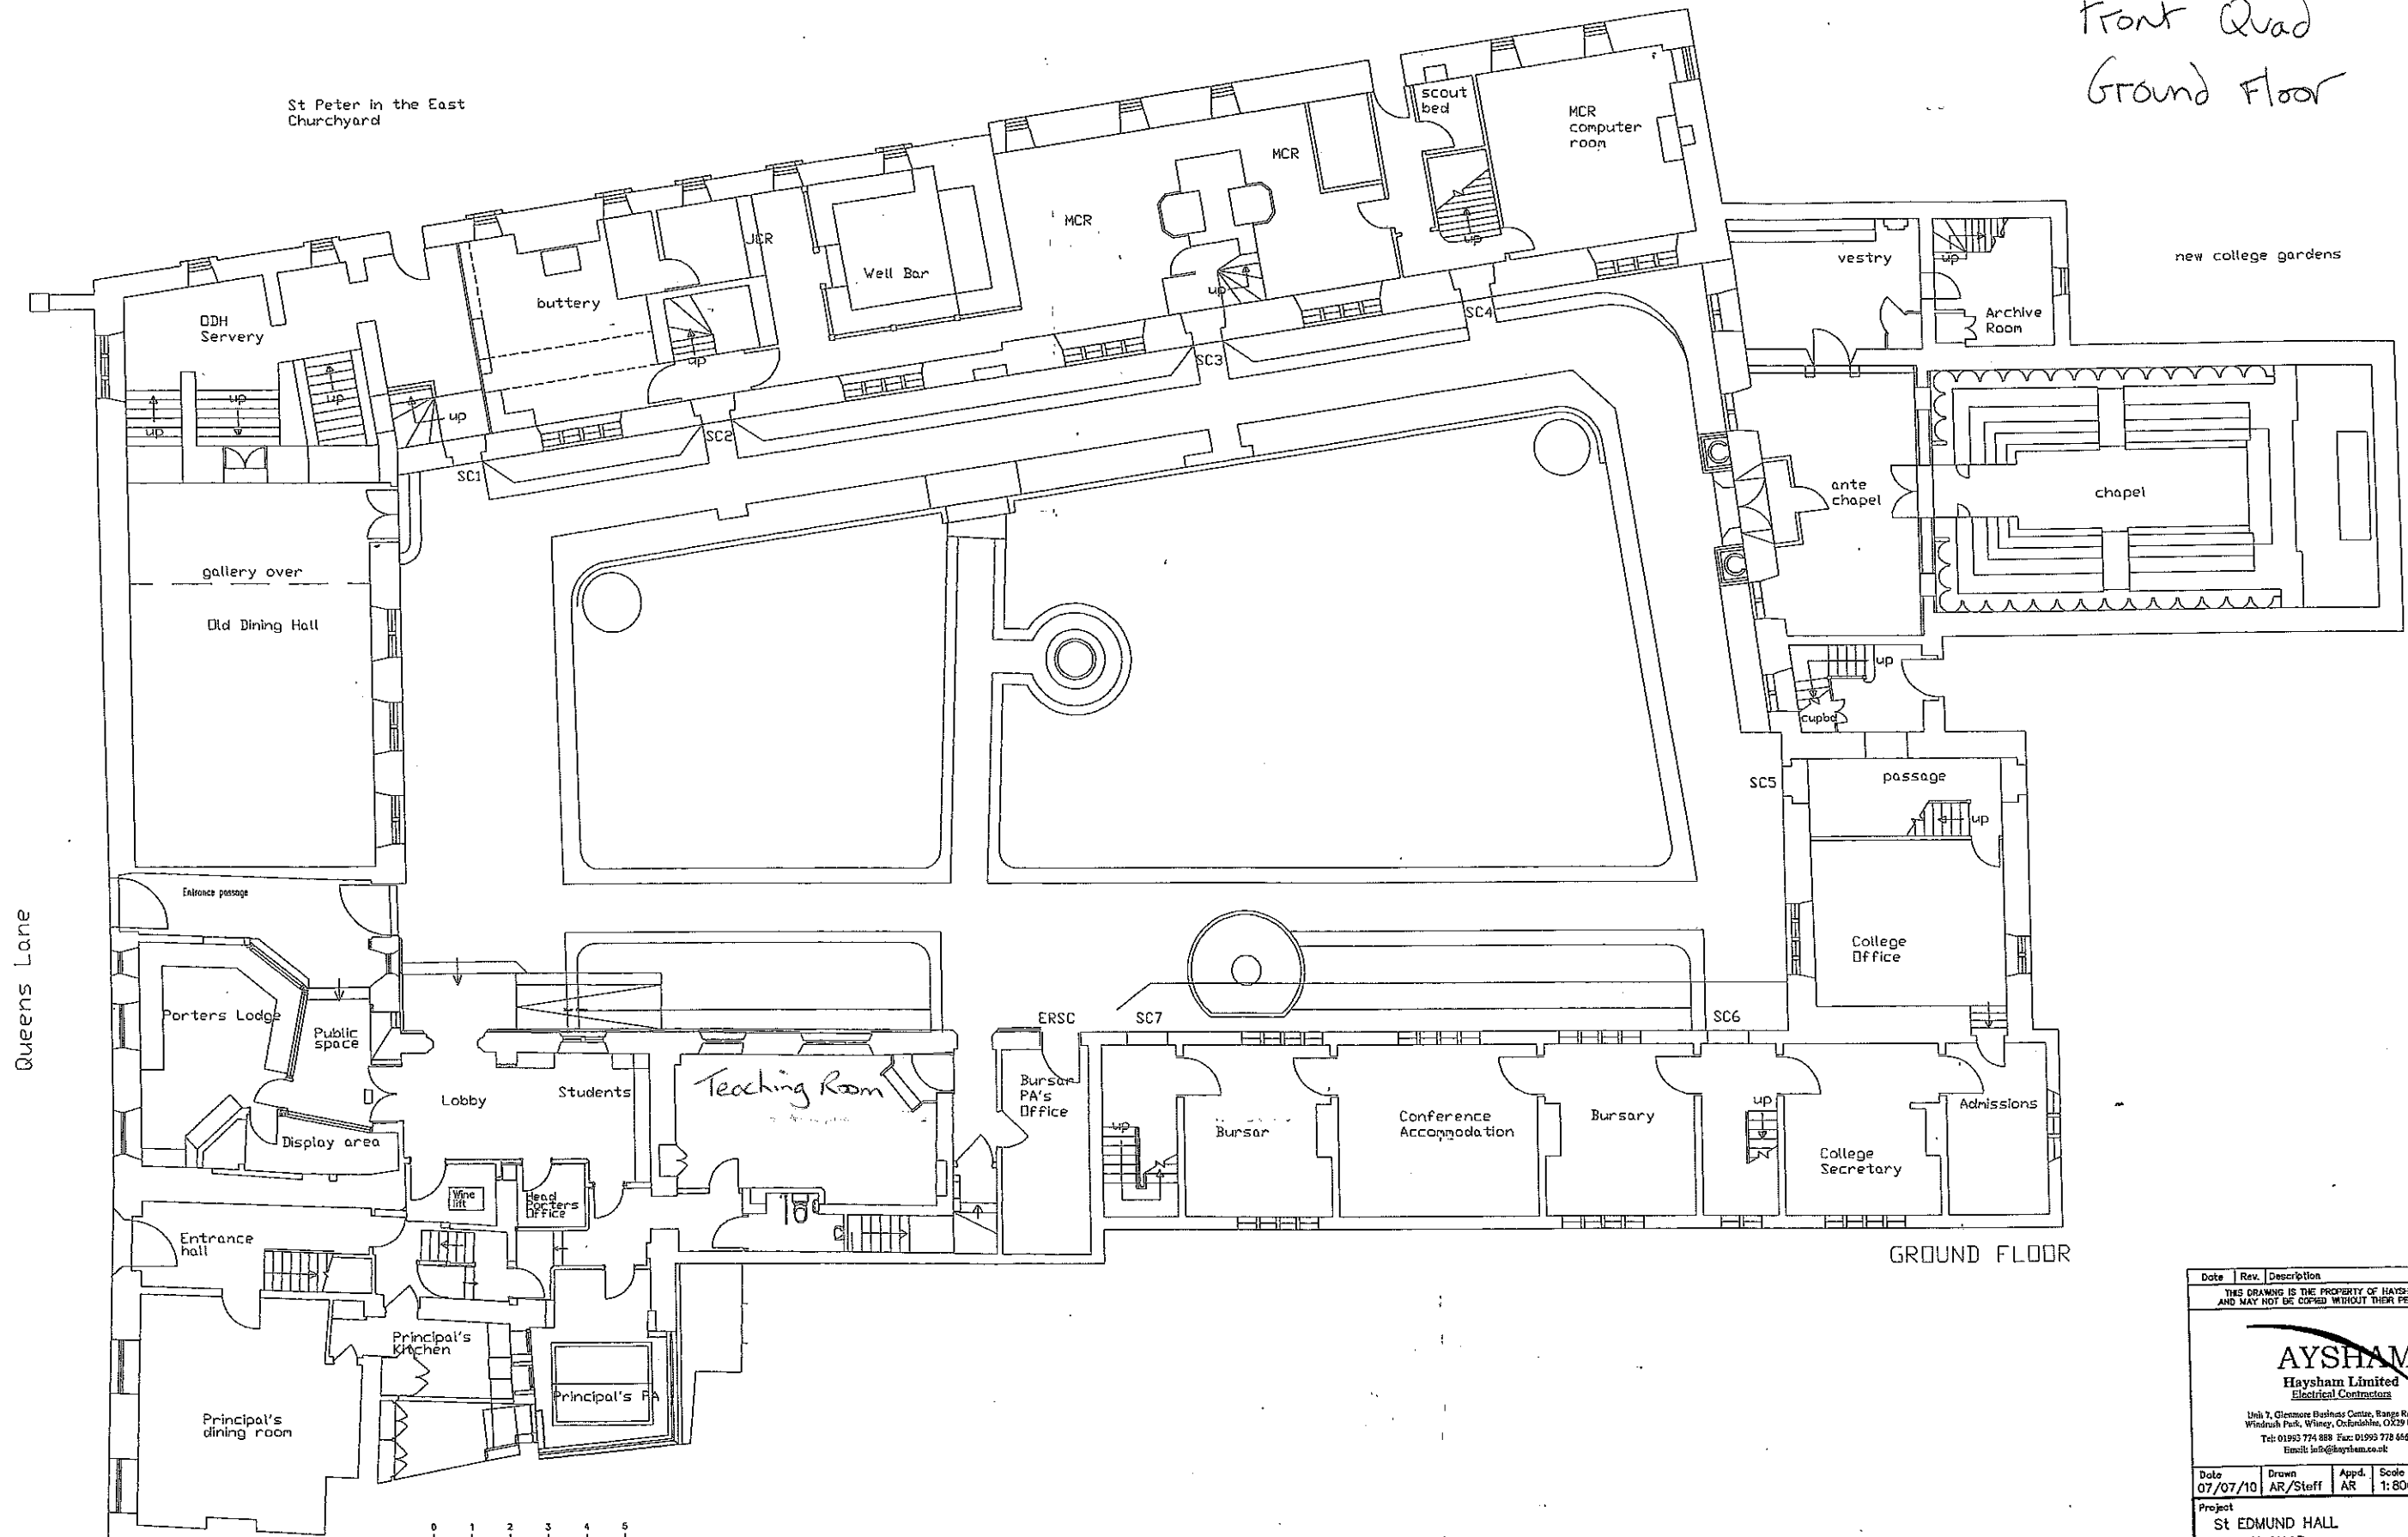


GROUND FLOOR

Date	Rev.	Description		
THIS DRAWING IS THE PROPERTY OF HAYSHAM LTD AND MAY NOT BE COPIED WITHOUT THEIR PERMISSION				
AYSHAM Haysham Limited Electrical Contractors <small>Unit 7, Clemore Business Centre, Range Road Windrush Park, Witney, Oxfordshire, OX29 0AA Tel: 01993 774 888 Fax: 01993 778 655 Email: info@aysham.co.uk</small>				
Date	Drawn	Appd.	Scale	A1
07/07/10	AR/Steiff	AR	1:800A1	
Project				
St EDMUND HALL FRONT QUAD				
Title				
GROUND FLOOR ELECTRICAL LAYOUT				
Drawing No.				Revision
001949-E-301				


AS INSTALLED

DO NOT SCALE

Front Quad
First floor

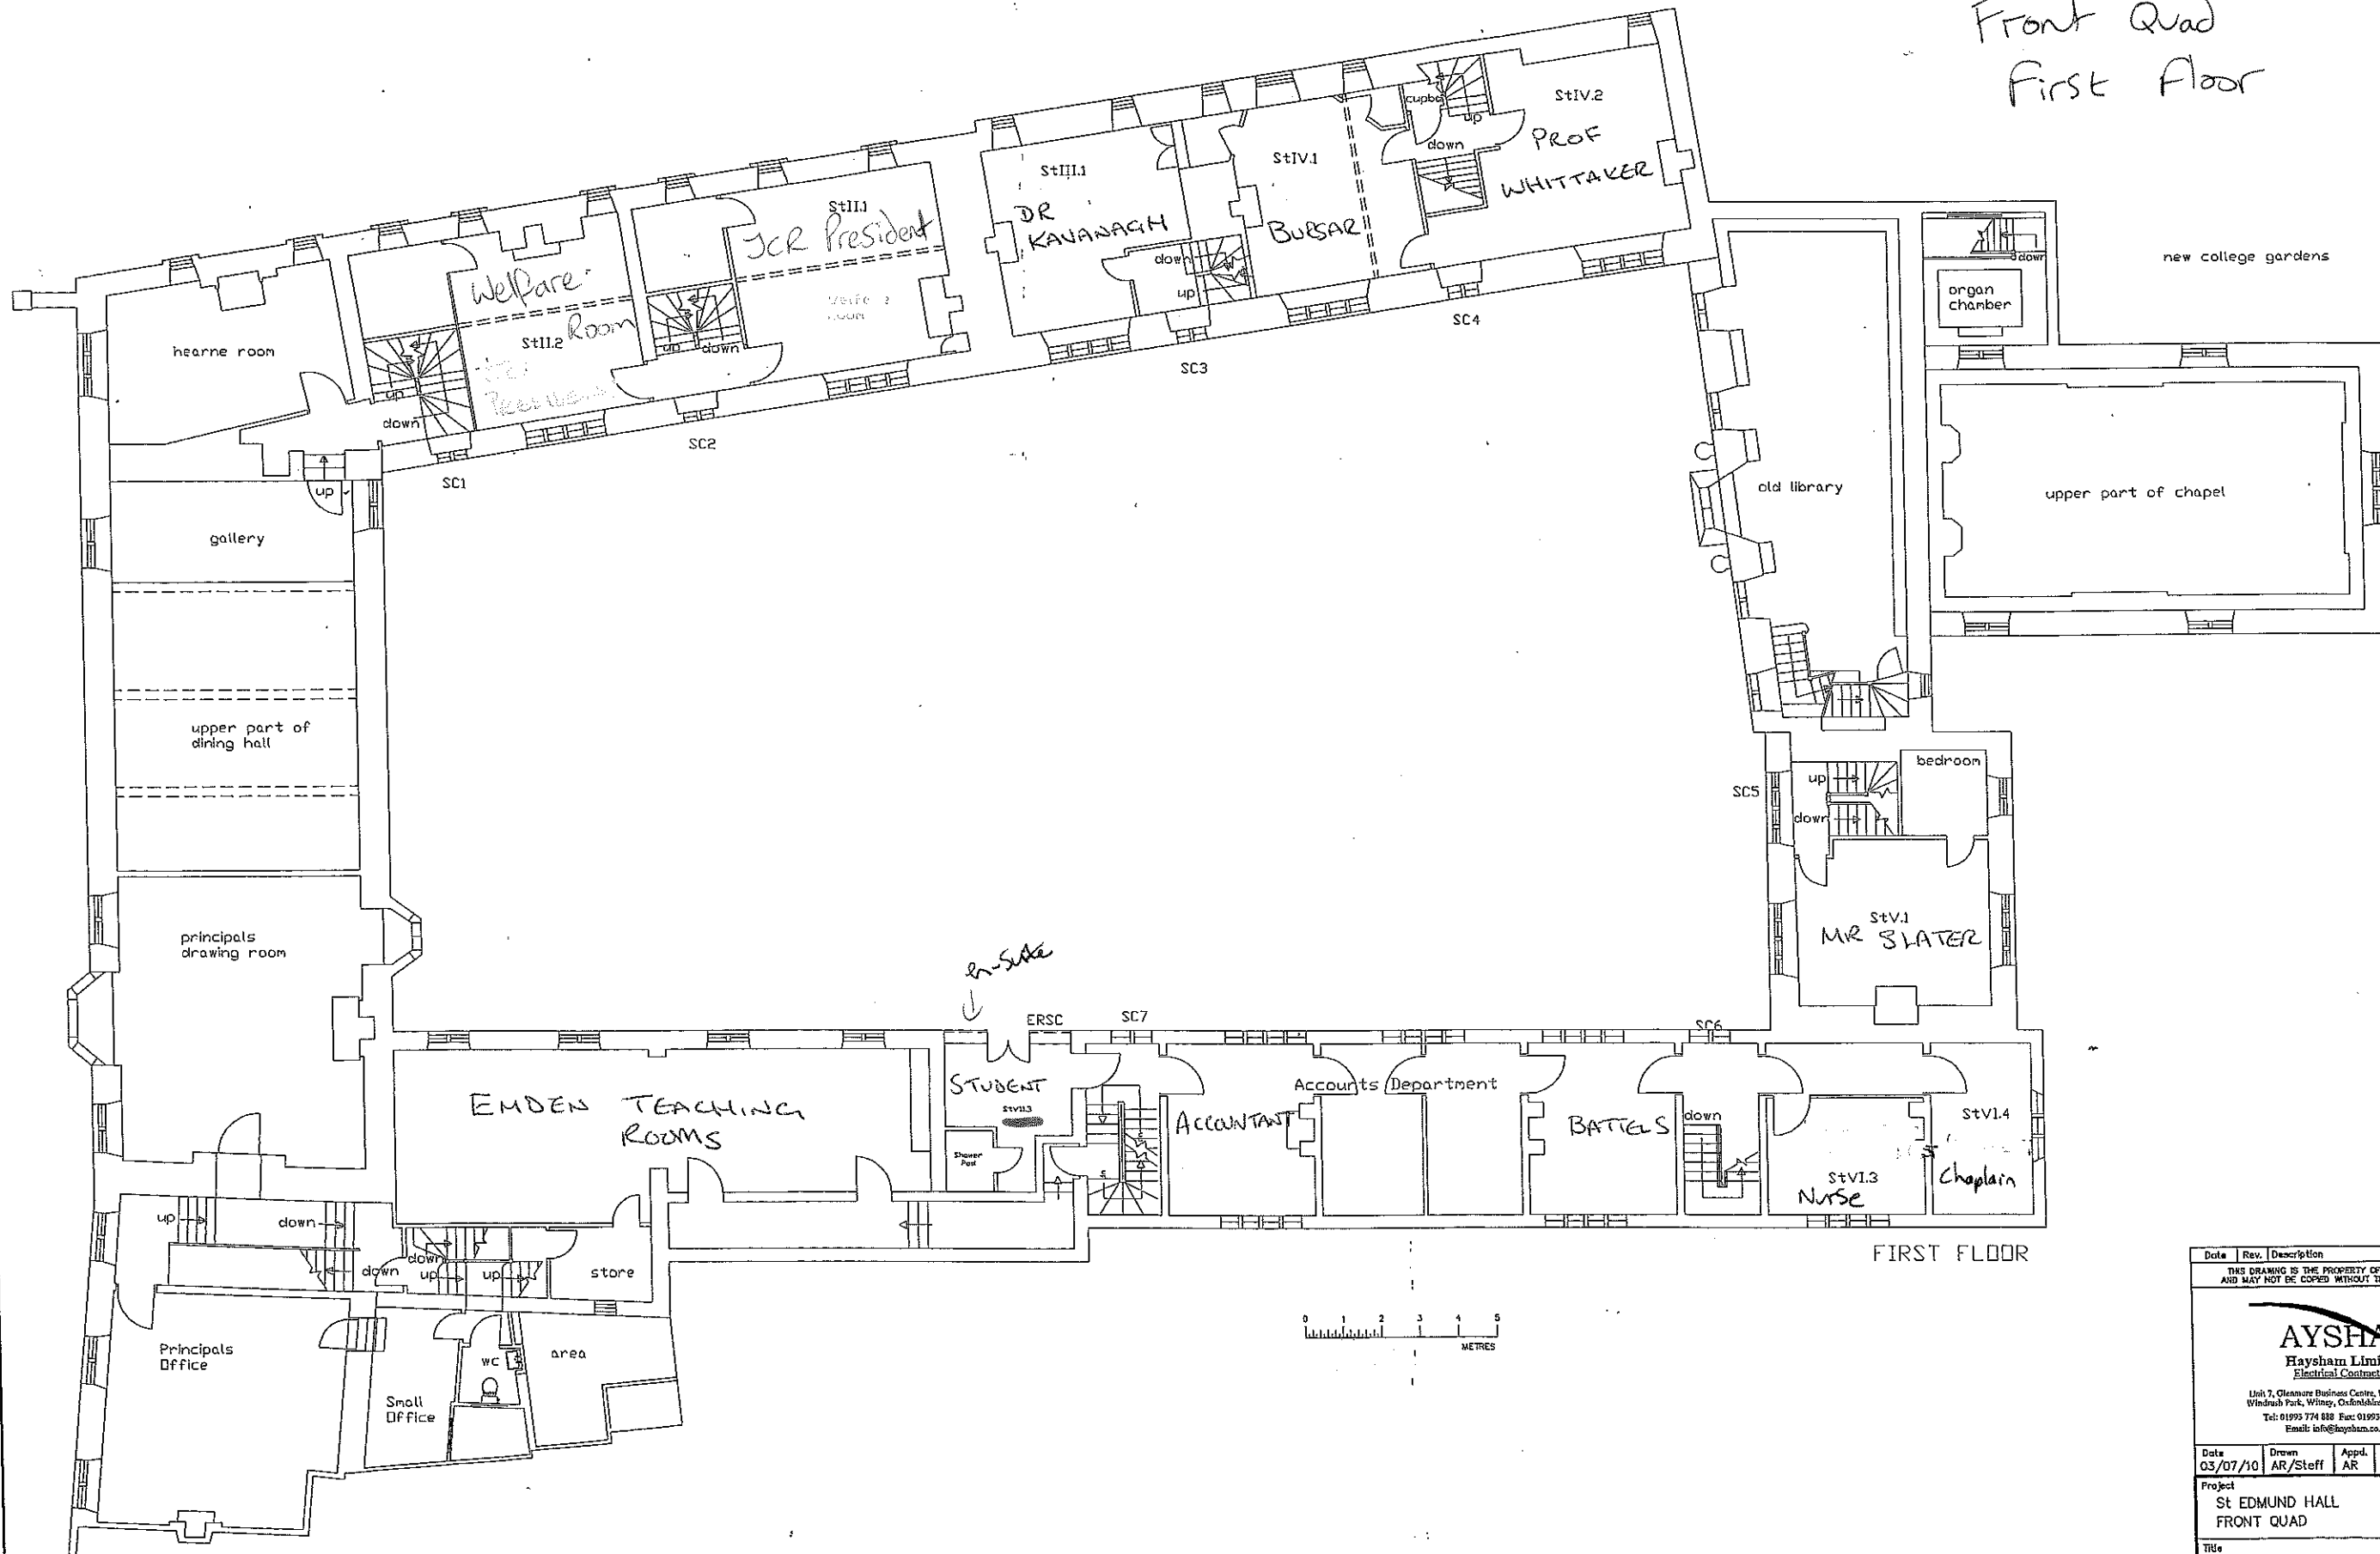

FIRST FLOOR

 


Date	Rev.	Description
THIS DRAWING IS THE PROPERTY OF HAYSHAM LTD AND MAY NOT BE COPIED WITHOUT THEIR PERMISSION		
AYSHAM Haysham Limited Electrical Contractors Unit 7, Gleamare Business Centre, Range Road Windrush Park, Witney, Oxfordshire, OX29 8AA Tel: 01993 774 888 Fax: 01993 778 666 Email: info@aysham.co.uk		
03/07/10	AR/Steff	Appd. AR Scale 1:800/A1
Project St EDMUND HALL FRONT QUAD		
Title FIRST FLOOR ELECTRICAL LAYOUT		
Drawing No. 001949-E-302		Revision

AS INSTALLED

DO NOT SCALE

Front Quad
Second floor

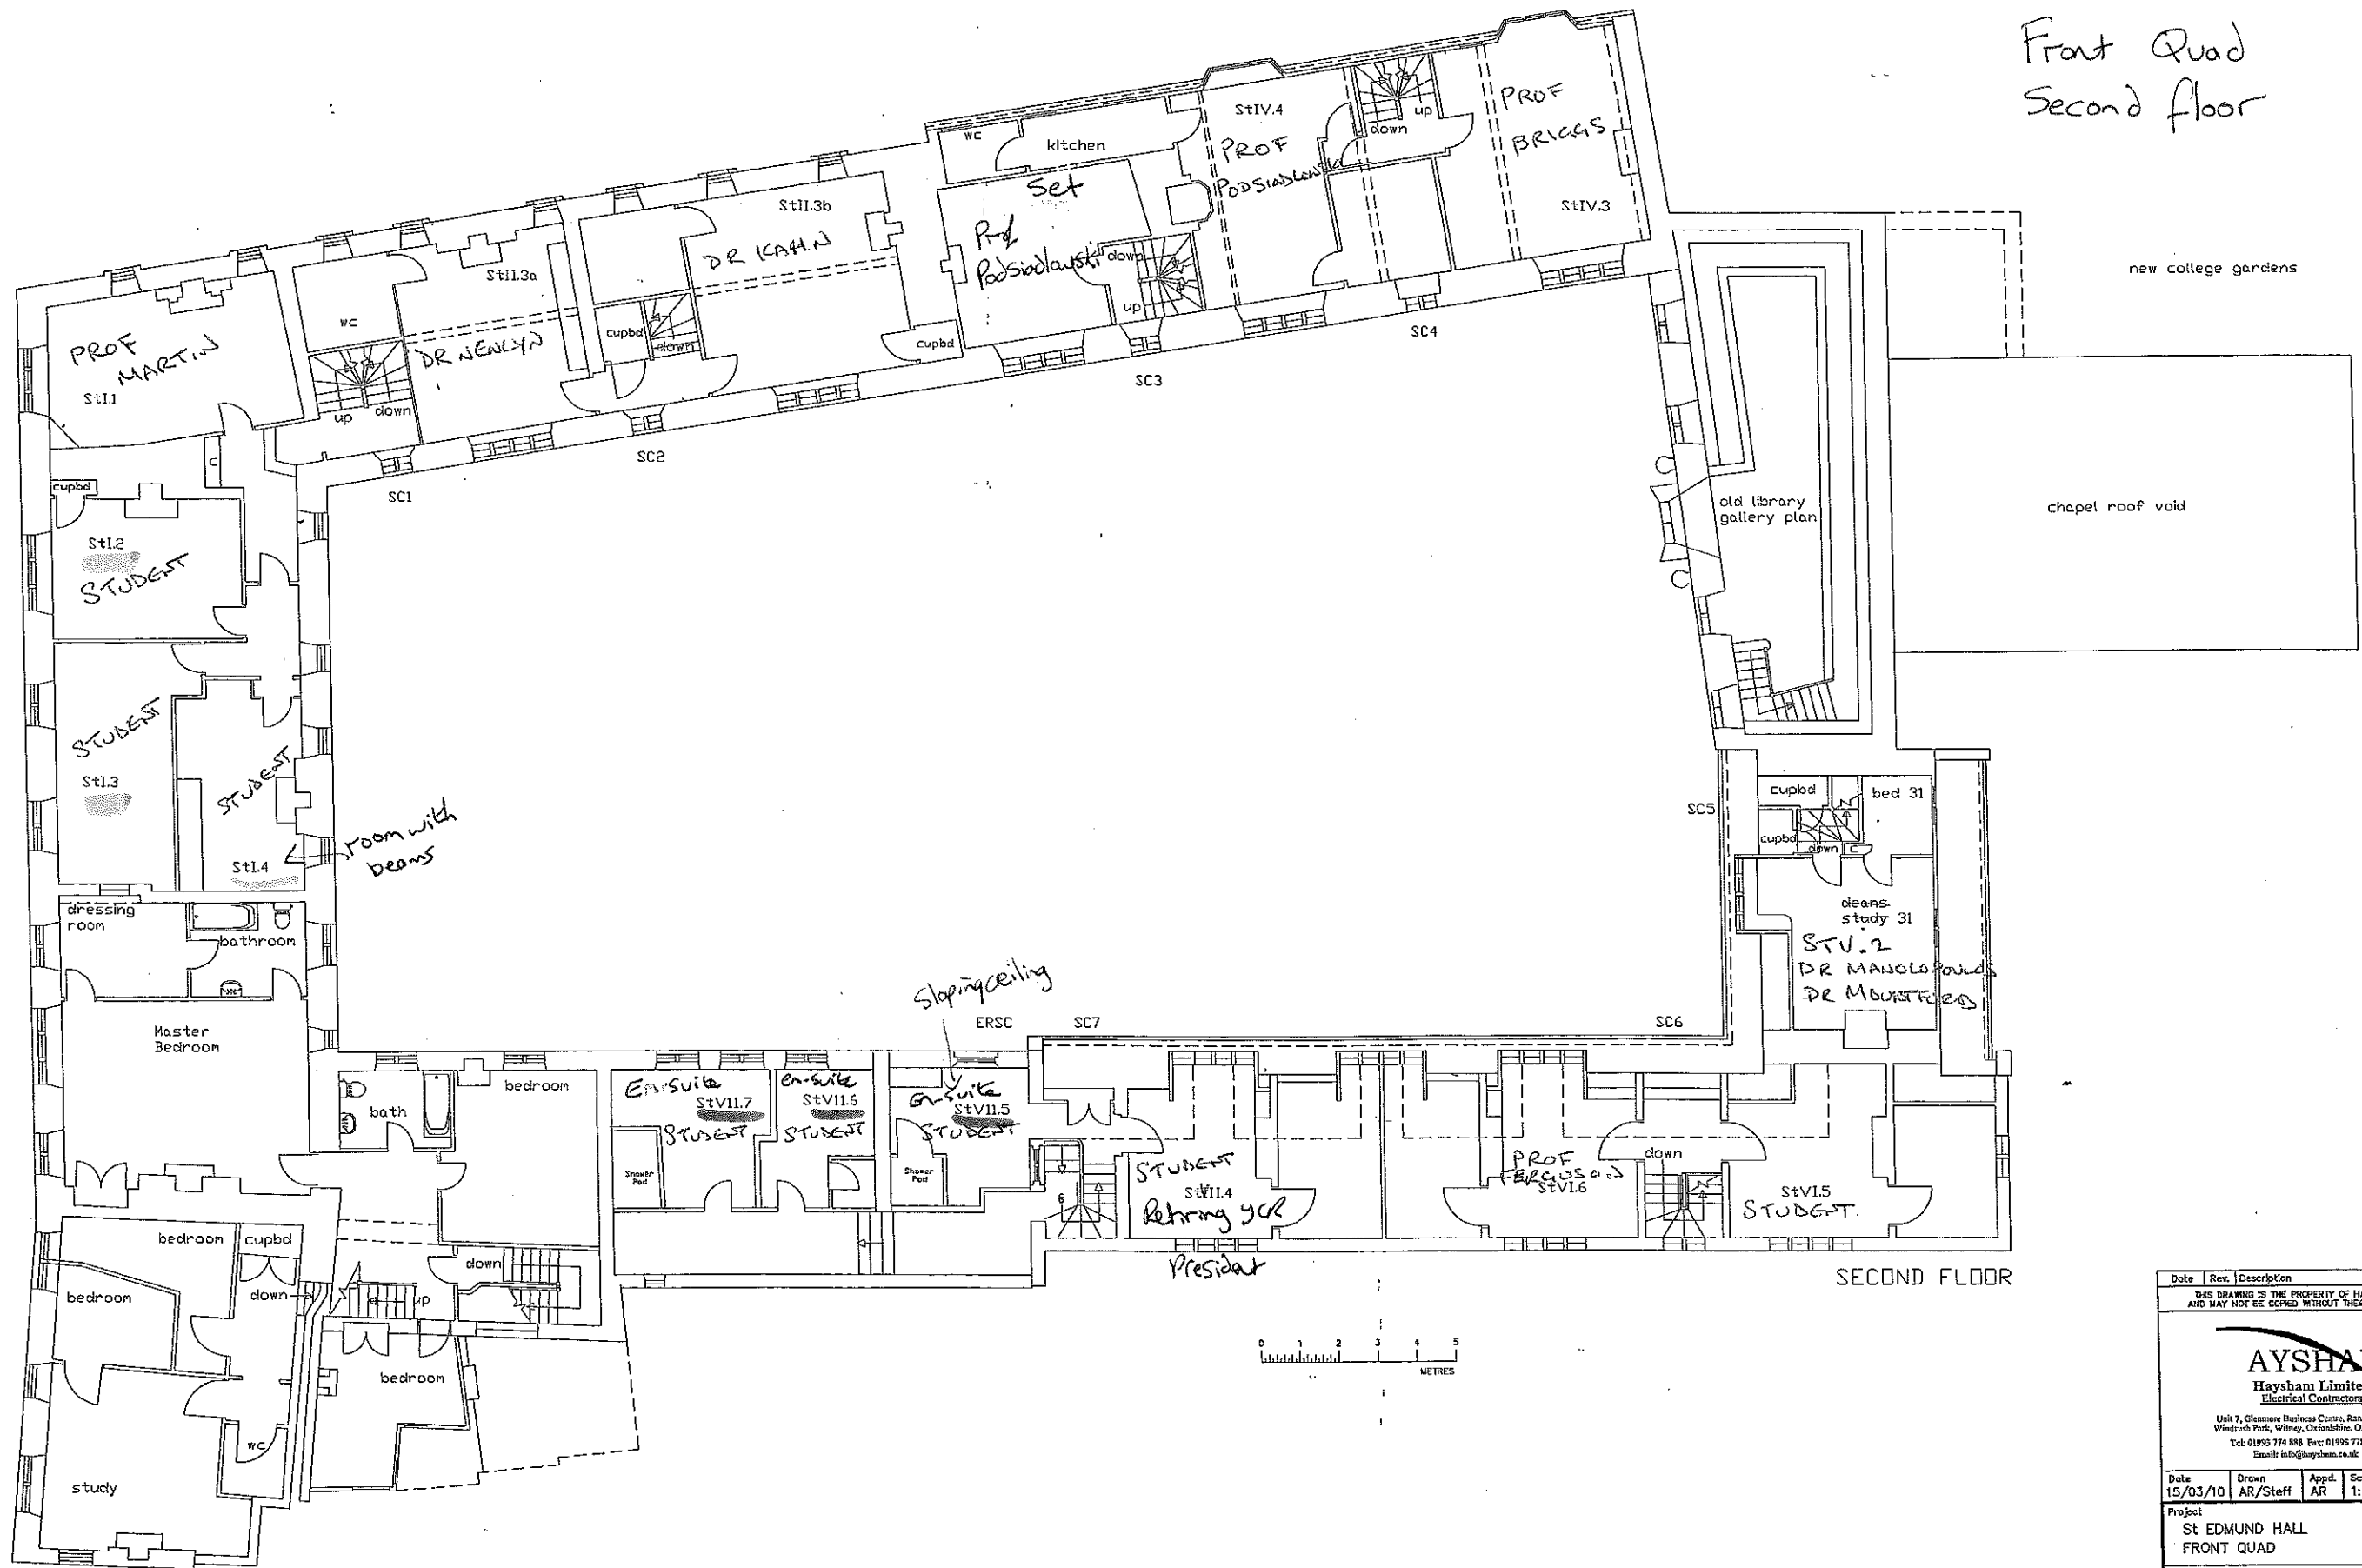

new college gardens

 
chapel roof void

Room with beams

Sloping ceiling

President

SECOND FLOOR




Date	Rev.	Description		
THIS DRAWING IS THE PROPERTY OF HAYSHAM LTD AND MAY NOT BE COPIED WITHOUT THEIR PERMISSION				
<small>Unit 7, Glenmore Business Centre, Range Road Windrush Park, Wilmslow, Cheshire, SK9 9AA Tel: 01992 774 888 Fax: 01992 778 666 Email: info@aysham.co.uk</small>				
Date	Drawn	Appd.	Scale	A1
15/03/10	AR/Staff	AR	1:800A1	
Project				
ST EDMUND HALL FRONT QUAD				
Title				
SECOND FLOOR ELECTRICAL LAYOUT				
Drawing No.		Revision		
001949-E-303				

AS INSTALLED

DO NOT SCALE

Front Quad
top floor

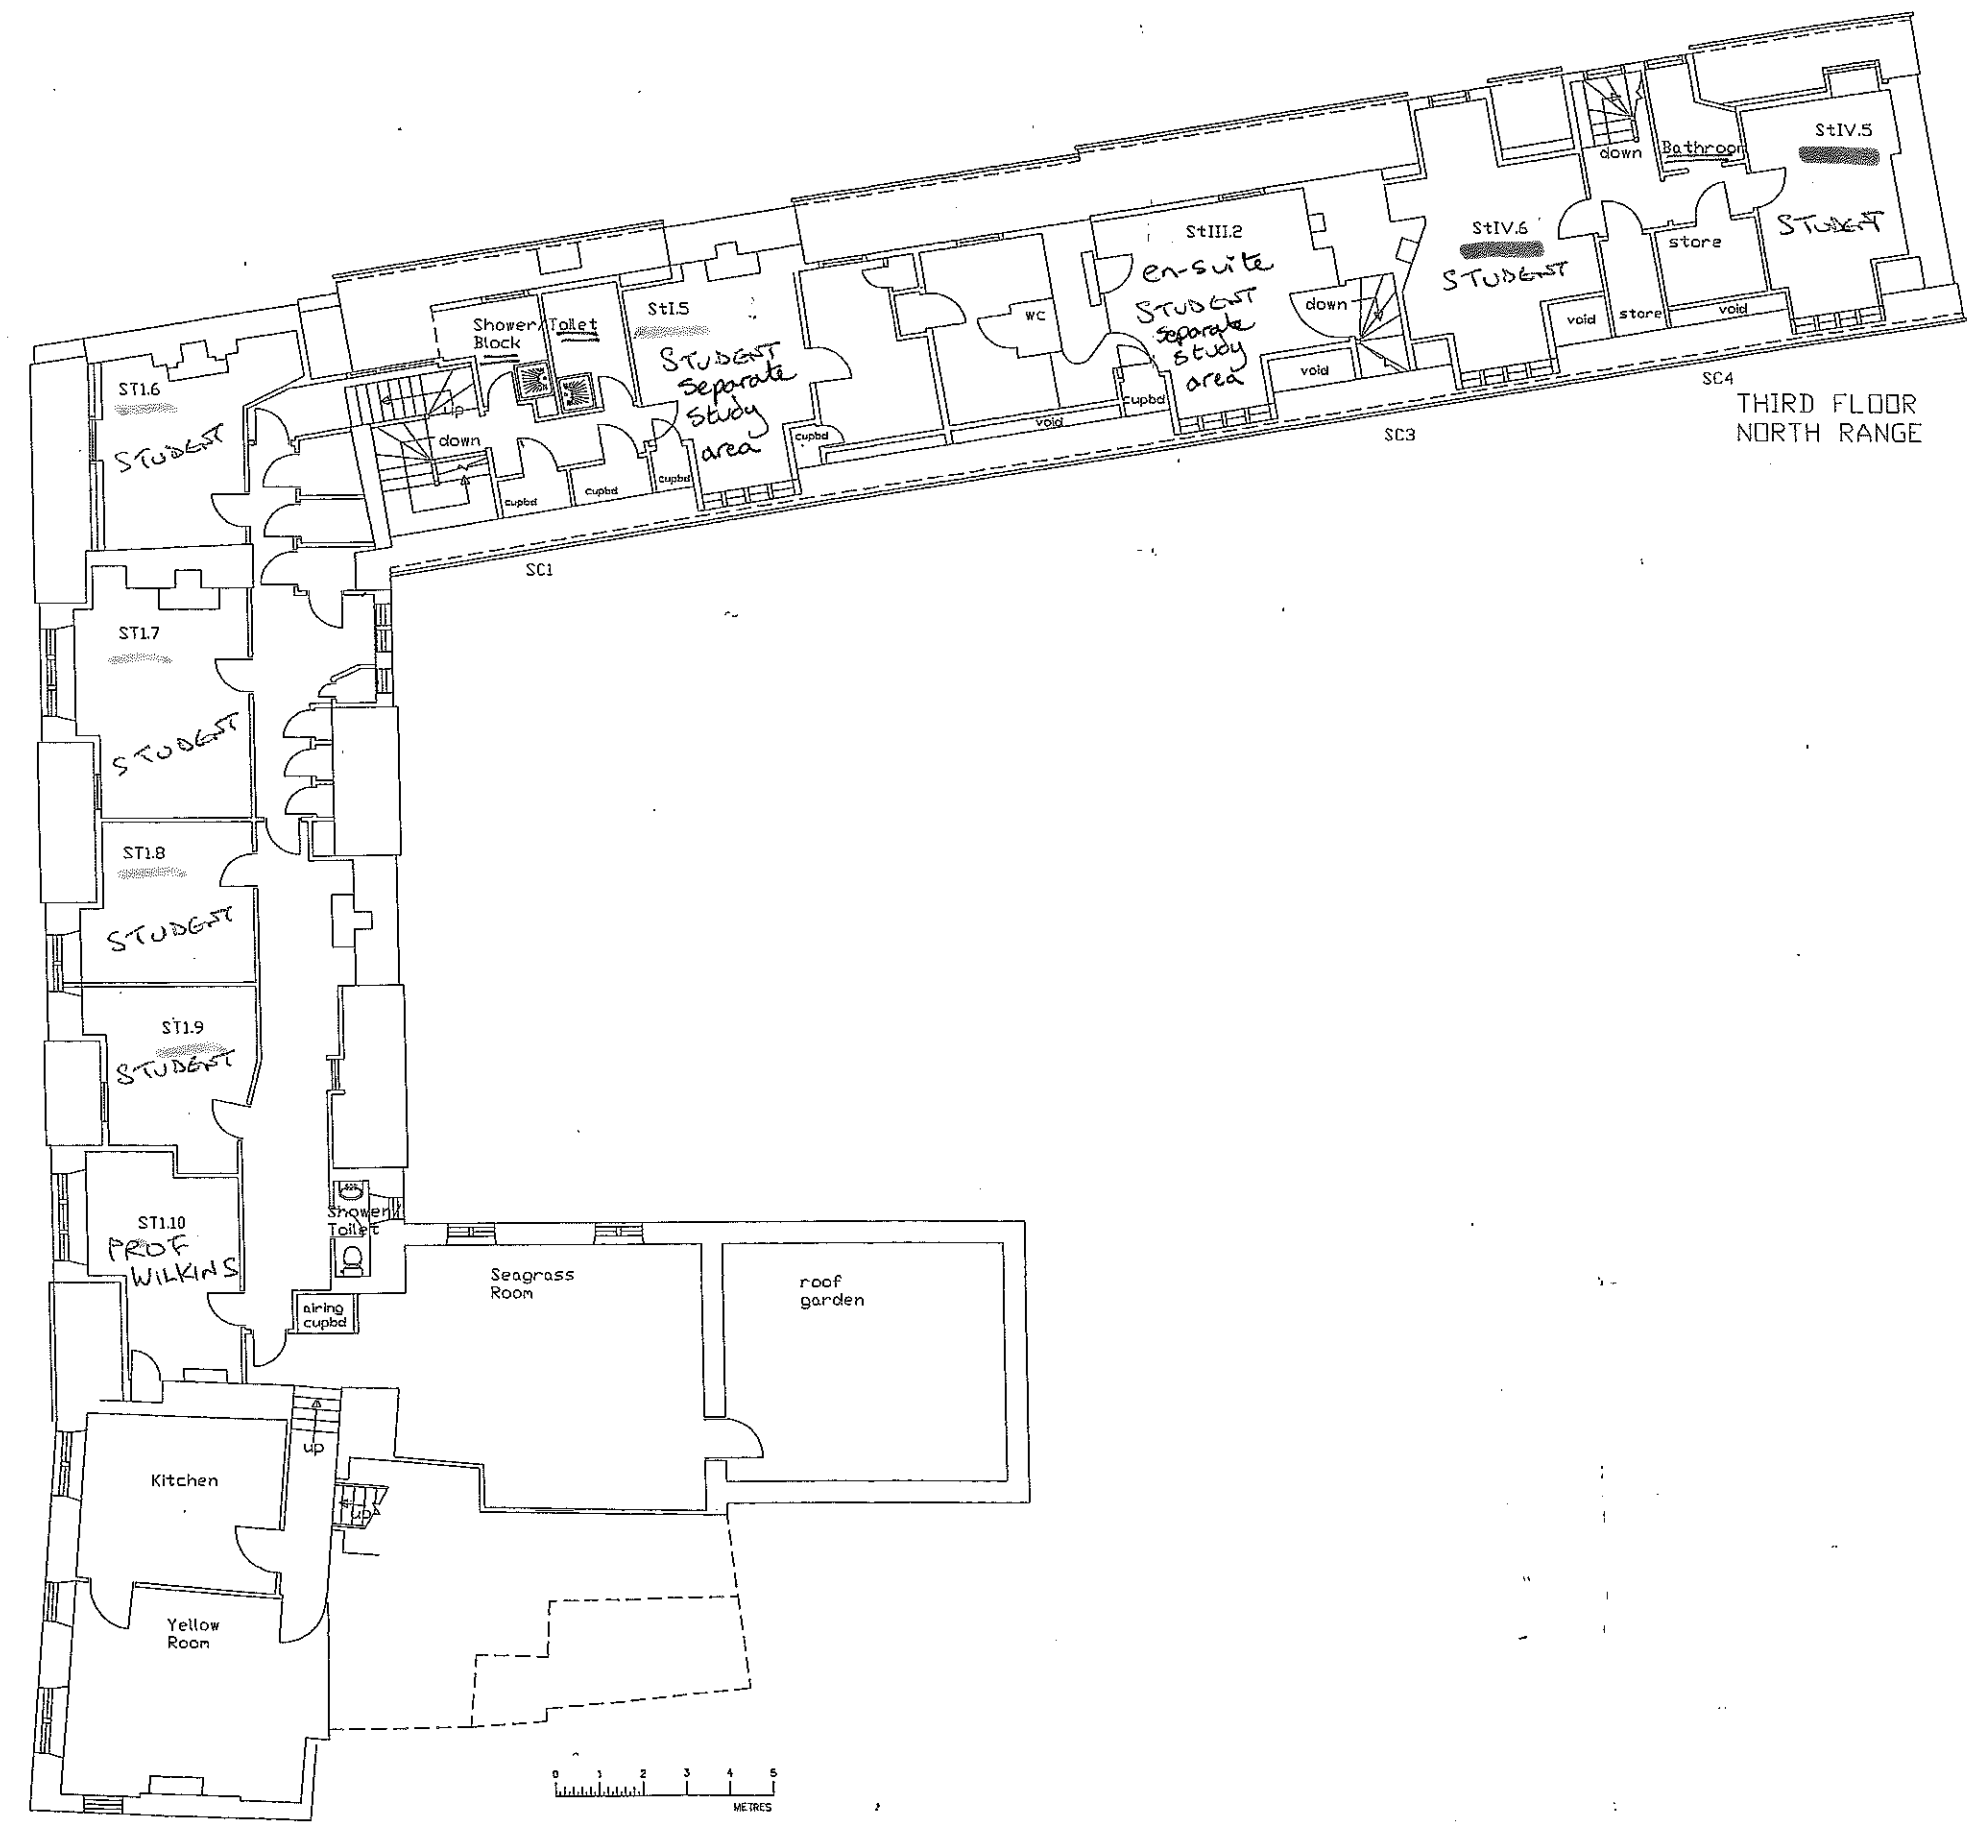

Date					Rev.					Description				
THIS DRAWING IS THE PROPERTY OF HAYSHAM LTD AND MAY NOT BE COPIED WITHOUT THEIR PERMISSION														
AYSHAM Haysham Limited Electrical Contractors														
<small>Unit 7, Glenmore Business Centre, Range Road Widnush Park, Witney, Oxfordshire, OX29 0AA Tel: 01995 774 888 Fax: 01995 778 666 Email: info@aysham.co.uk</small>														
Date 03/07/10			Drawn AR/Steff			Appd. AR			Scale 1:50@A1			A1		
Project ST EDMUND HALL FRONT QUAD														
Title THIRD FLOOR ELECTRICAL LAYOUT														
Drawing No. 001949-E--304										Revision				

AS INSTALLED