


NOTES

- Survey is based on an arbitrary grid.
- All levels relate to Ordnance Survey Datum from GPS observations to the National GPS Network transformed using OSGM02.

ABBREVIATIONS

AL	Arch Level	MH	Manhole
BSU	Beam Slopes Up	PI	Plinth
Co	Column	R	Riser
CR	Collar Level	RD	Radiator
CSU	Ceiling Slopes Up	RL	Roof Light
DP	Down Pipe	SC	Structural Ceiling Level
FC	Falsed Ceiling	SL	Sill Level
FE	Fire Escape	SP	Springing Point Level
FFL	Finished Floor Level	TB	Top of Beam Level
GU	Gully	TW	Top of Wall Level
HL	Head Level	UB	Underside of Beam Level
HR	Hand Rail	US	Underside of Service Level
IC	Inspection Cover	VP	Vent Pipe

- SERVICES KEY**
- Electric Meter
 - Gas Meter
 - Water Meter
 - Isolation Valve
 - Consumer Unit
 - Fire Control Panel
 - Misc. Control Panel
 - Single Socket
 - Double Socket
 - Triple Socket
 - Quad Socket
 - Fused Spur
 - Outlet
 - Cooker Socket
 - Floor Box (FB X sockets)
 - Room Thermostat
 - CH Time Clock
 - Aerial Socket
 - Telephone Socket
 - Data Socket
 - Shaver Socket
 - LV Transformer
 - Junction Box
 - Emergency Test Switch
 - Switch (No. of Gangs)
 - Pull Switch
 - Light
 - Wall Light
 - Batten Light
 - Emergency Light
 - Smoke Detector
 - Call Point
 - Bell
 - Security Camera
 - Bell Push
 - Extractor Vent
 - Magnetic Door Hold
 - Door Access Panel
 - Carbon Monoxide Detector

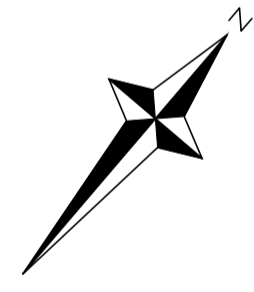

Rev.	Description	Date	Chkd
------	-------------	------	------

Glanville
 Cornerstone House
 62 Foxhall Road, Didcot
 Oxon, OX11 7AD
 Tel: (01235) 515550 Fax: (01235) 817799
 postbox@glanvillegroup.com www.glanvillegroup.com


Client : **ST EDMUND HALL**

Project : **26 NORHAM GARDENS
 OXFORD, OX2 6QD**

Title : **FLATS A-J
 GROUND FLOOR PLAN**

Project Engineer : JS Scale : 1:50 @ A1
 Project Director : CE Date : AUG 2013

Status :
 Drawing No. **GS8130799/103** Rev

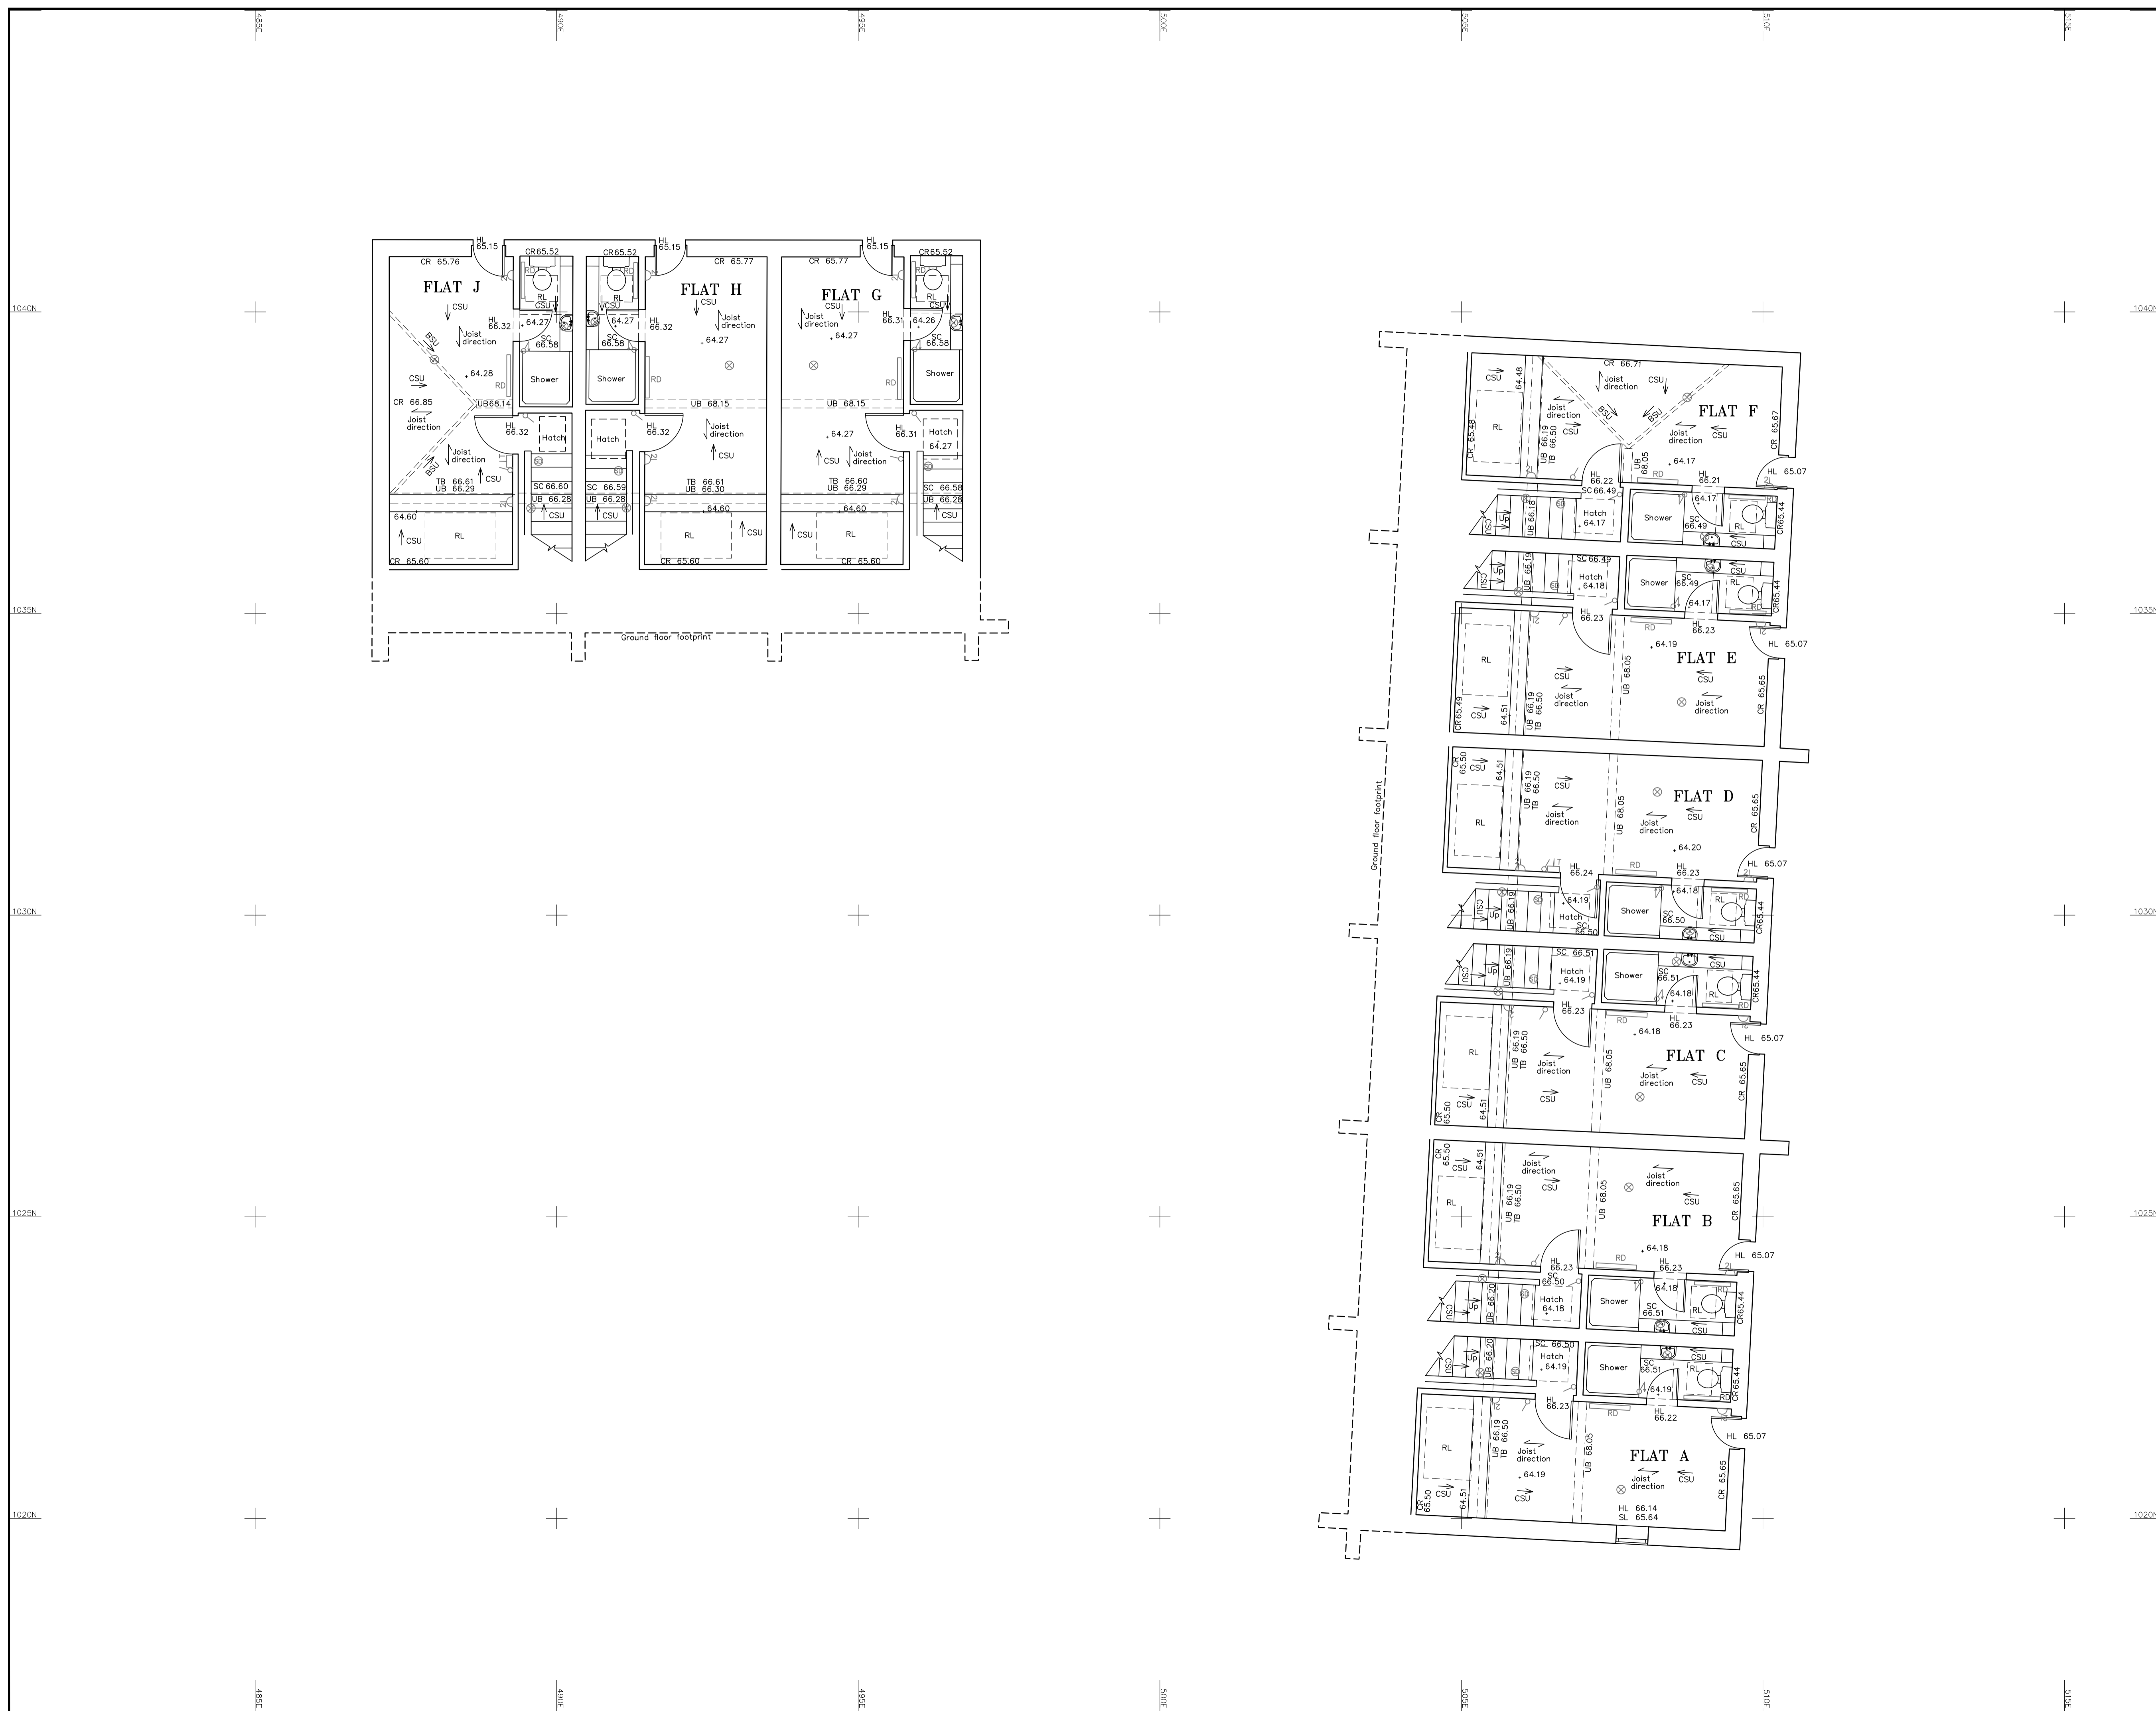

NOTES


1. Survey is based on an arbitrary grid.
2. All levels relate to Ordnance Survey Datum from GPS observations to the National GPS Network transformed using OSGM02.

ABBREVIATIONS

AL	Arch Level	MH	Manhole
BSU	Beam Slopes Up	PI	Plinth
Co	Column	R	Riser
CR	Collar Level	RD	Radiator
CSU	Ceiling Slopes Up	RL	Roof Light
DP	Down Pipe	SC	Structural Ceiling Level
FC	Falsed Ceiling	SL	Sill Level
FE	Fire Escape	SP	Springing Point Level
FFL	Finished Floor Level	TB	Top of Beam Level
GU	Gully	TW	Top of Wall Level
HL	Head Level	UB	Underside of Beam Level
HR	Hand Roll	US	Underside of Service Level
IC	Inspection Cover	VP	Vent Pipe

SERVICES KEY

- Electric Meter
- Gas Meter
- Water Meter
- Isolation Valve
- Consumer Unit
- Fire Control Panel
- Misc. Control Panel
- Single Socket
- Double Socket
- Triple Socket
- Quad Socket
- Fused Spur
- Outlet
- Cooker Socket
- Floor Box (FB X sockets)
- Room Thermostat
- CH Time Clock
- Aerial Socket
- Telephone Socket
- Data Socket
- Shaver Socket
- LV Transformer
- Junction Box
- Emergency Test Switch
- Switch (No. of Gangs)
- Pull Switch
- Light
- Wall Light
- Batten Light
- Emergency Light
- Smoke Detector
- Call Point
- Bell
- Security Camera
- Bell Push
- Extractor Vent
- Magnetic Door Hold
- Door Access Panel
- Carbon Monoxide Detector

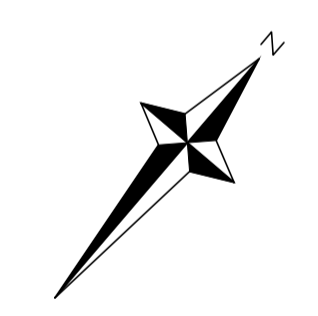

Rev.	Description	Date	Chkd
------	-------------	------	------

Glanville
 Cornerstone House
 62 Foxhall Road, Didcot
 Oxon, OX11 7AD
 Tel: (01235) 515550 Fax: (01235) 817799
 postbox@glanvillegroup.com www.glanvillegroup.com

Client : **ST EDMUND HALL**

Project : **26 NORHAM GARDENS
 OXFORD, OX2 6QD**

Title : **FLATS A-J
 FIRST FLOOR PLAN**

Project Engineer : JS Scale : 1:50 @ A1
 Project Director : CE Date : AUG 2013

Status : Rev

Drawing No. **GS8130799/104**