


DO NOT SCALE



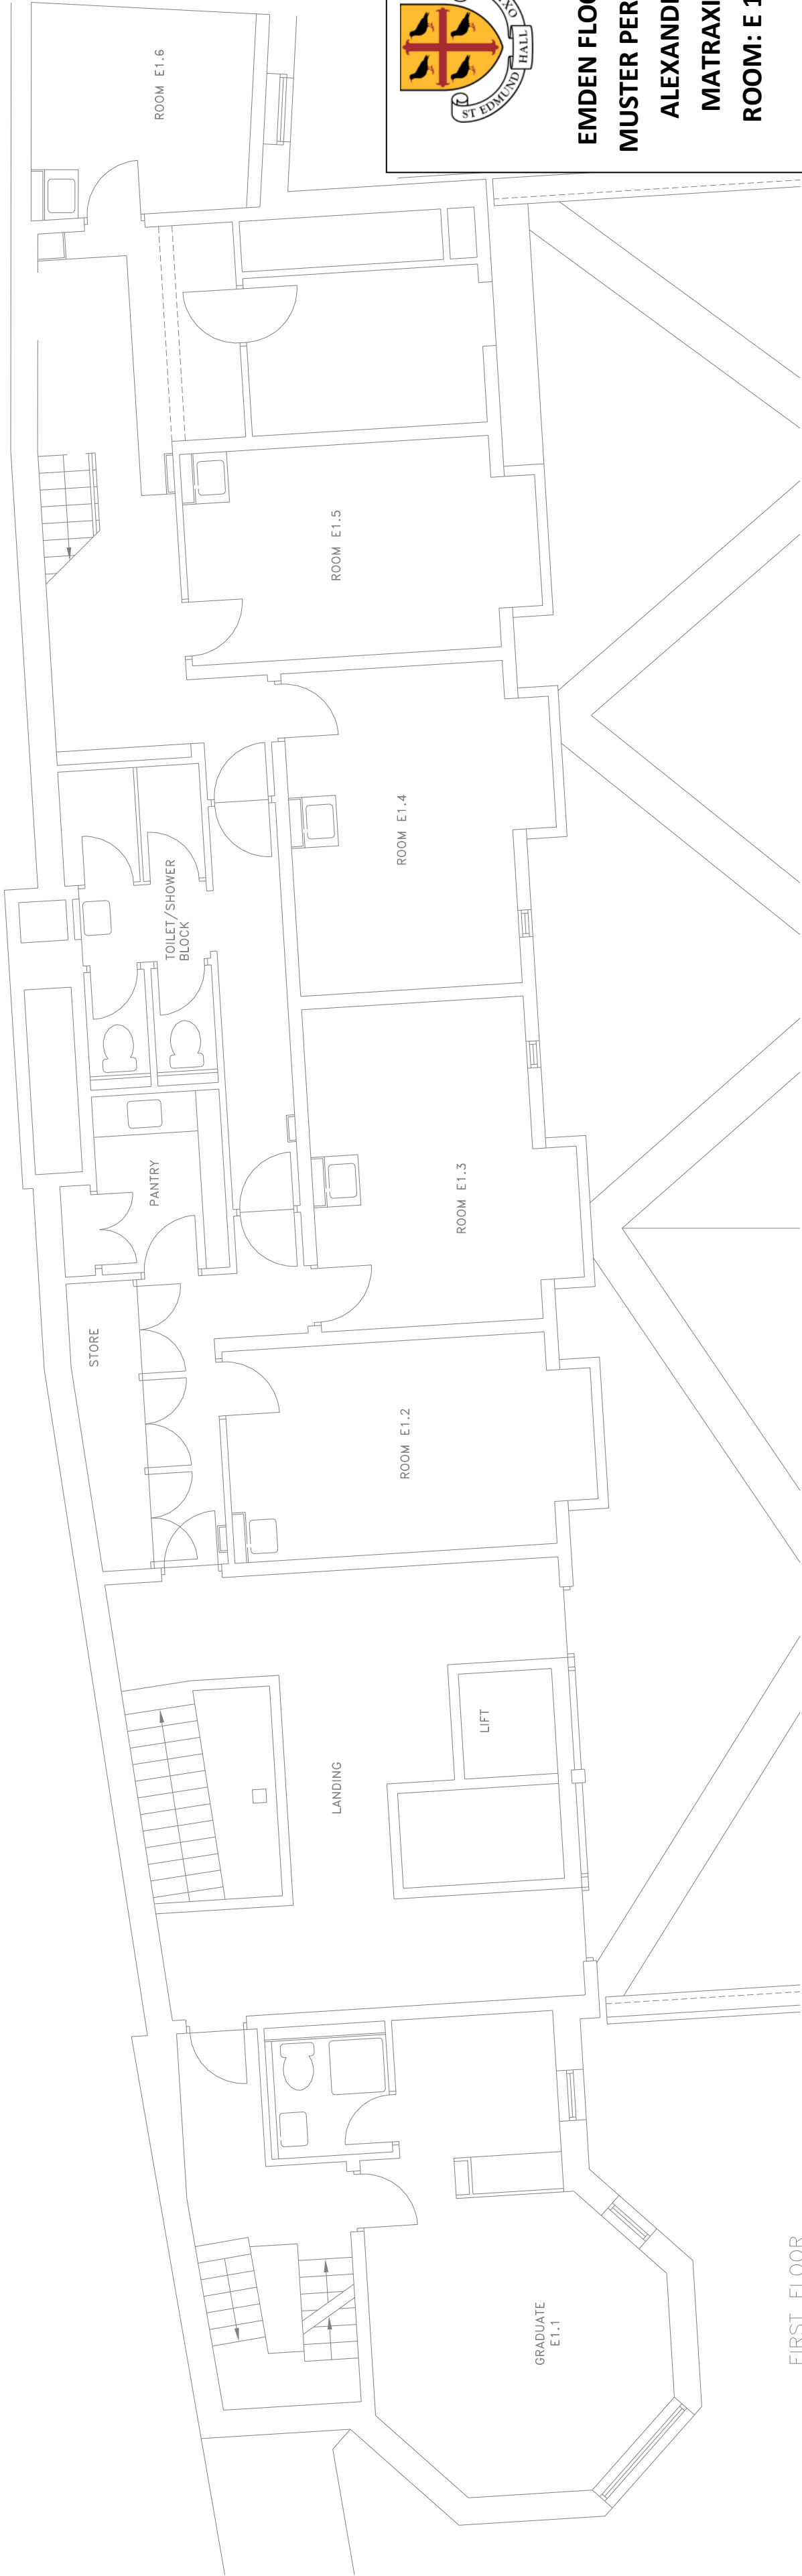

EMDEN FLOOR 1
MUSTER PERSON:
ALEXANDER
MATRAXIA
ROOM: E 1.3



Date	Rev.	Description
THIS DRAWING IS THE PROPERTY OF HAYSHAM LTD AND MAY NOT BE COPIED WITHOUT THEIR PERMISSION		


 Haysham Limited ELECTRICAL COLLABORATIONS Unit 7, Glenmore Business Centre, Range Road Windish Park, Wincey, Oxfordshire, OX29 0AA Tel: 01993 774 888 Fax: 01993 778 666 Email: info@haysham.co.uk		
Date	Drawn	Appd.
15/06/10	AR/Steff	AR
Scale		1:50⊕A1
A1		

Project		
St EDMUND HALL		
EMDEN BUILDING		

Title		
FIRST FLOOR		
ELECTRICAL LAYOUT		

Drawing No.		Revision
001949-E-502		

DO NOT SCALE

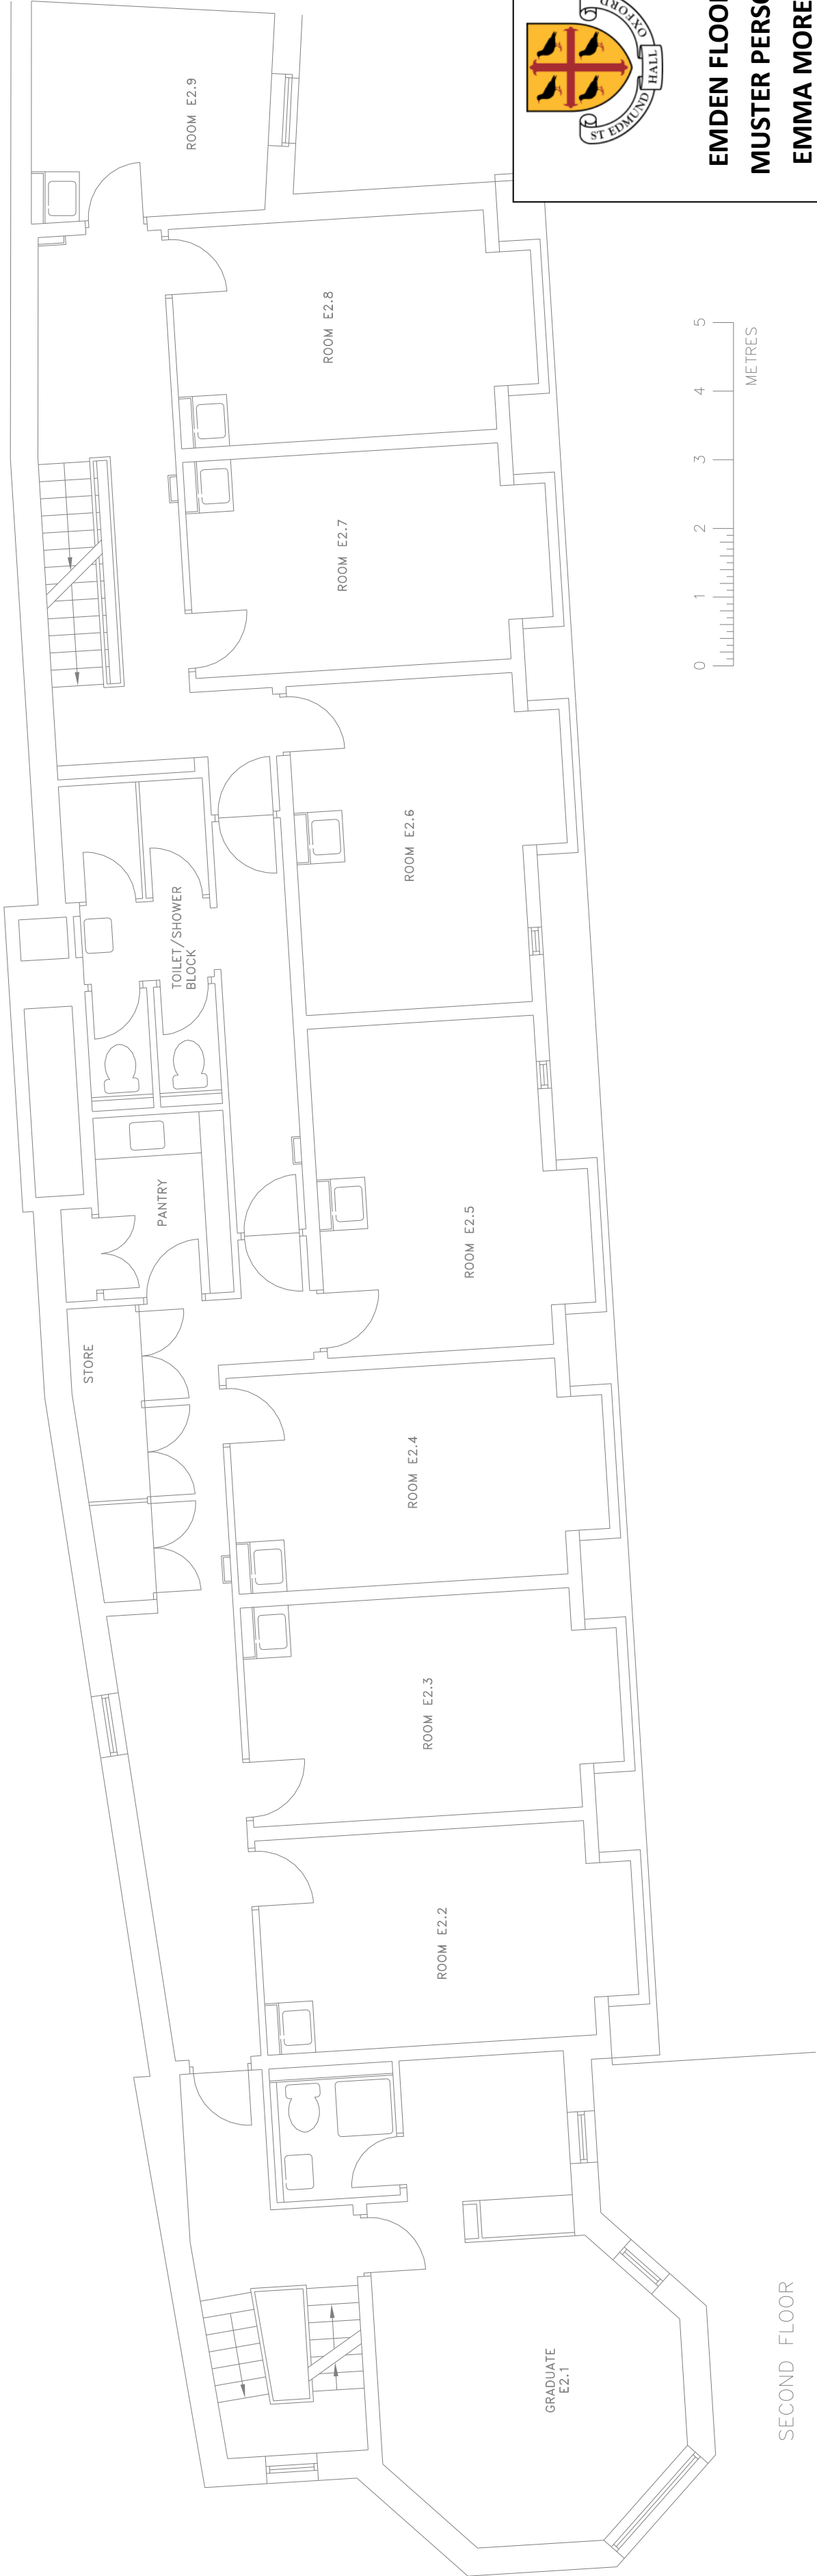




EMDEN FLOOR 2
MUSTER PERSON:
EMMA MOREBY
ROOM: E 2.2

Date	Rev.	Description	
THIS DRAWING IS THE PROPERTY OF HAYSHAM LTD AND MAY NOT BE COPIED WITHOUT THEIR PERMISSION			
 Unit 7, Glenmore Business Centre, Range Road Windrush Park, Winney, Oxfordshire, OX29 0AA Tel: 01993 774 888 Fax: 01993 778 666 Email: info@haysham.co.uk			
Date	Drawn	Appd.	Scale
15/06/10	AR/Steff	AR	1:50⊕A1
Project			
St EDMUND HALL EMDEN BUILDING			
Title			
SECOND FLOOR ELECTRICAL LAYOUT			
Drawing No.		Revision	
001949-E-503			

DO NOT SCALE

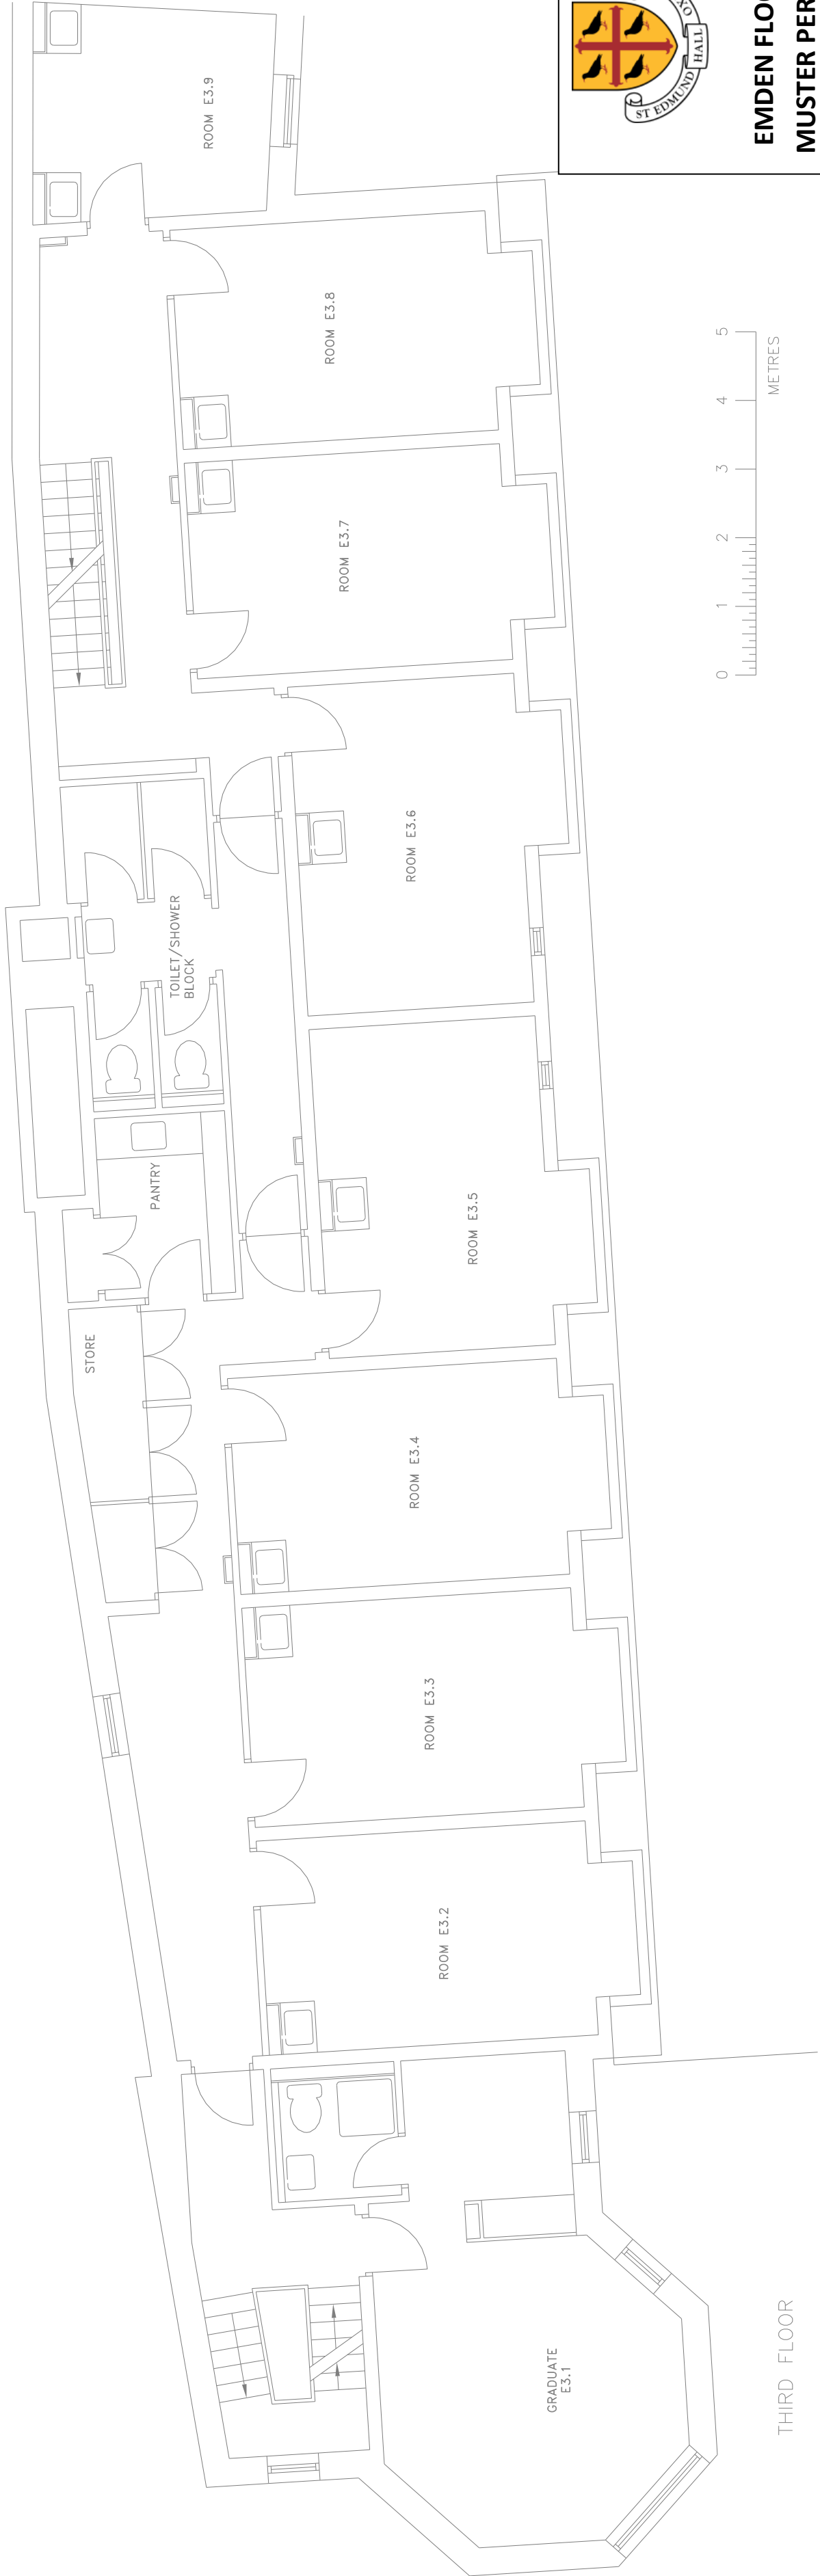



EMDEN FLOOR 3

MUSTER PERSON:

JOANNA MALE

ROOM: E 3.2

Date	Rev.	Description
THIS DRAWING IS THE PROPERTY OF HAYSHAM LTD AND MAY NOT BE COPIED WITHOUT THEIR PERMISSION		


 Haysham Limited ELECTRICAL COLLABOROUS Unit 7, Glenmore Business Centre, Range Road, Windish Park, Wincey, Oxfordshire, OX29 0AA Tel: 01993 774 888 Fax: 01993 778 666 Email: info@haysham.co.uk		
Date	Drawn	Appd.
15/06/10	AR/Steff	AR
Scale	1:50⊕A1	
A1		

Project		
St EDMUND HALL		
EMDEN BUILDING		

Title		
THIRD FLOOR		
ELECTRICAL LAYOUT		

Drawing No.		Revision
001949-E-504		

DO NOT SCALE

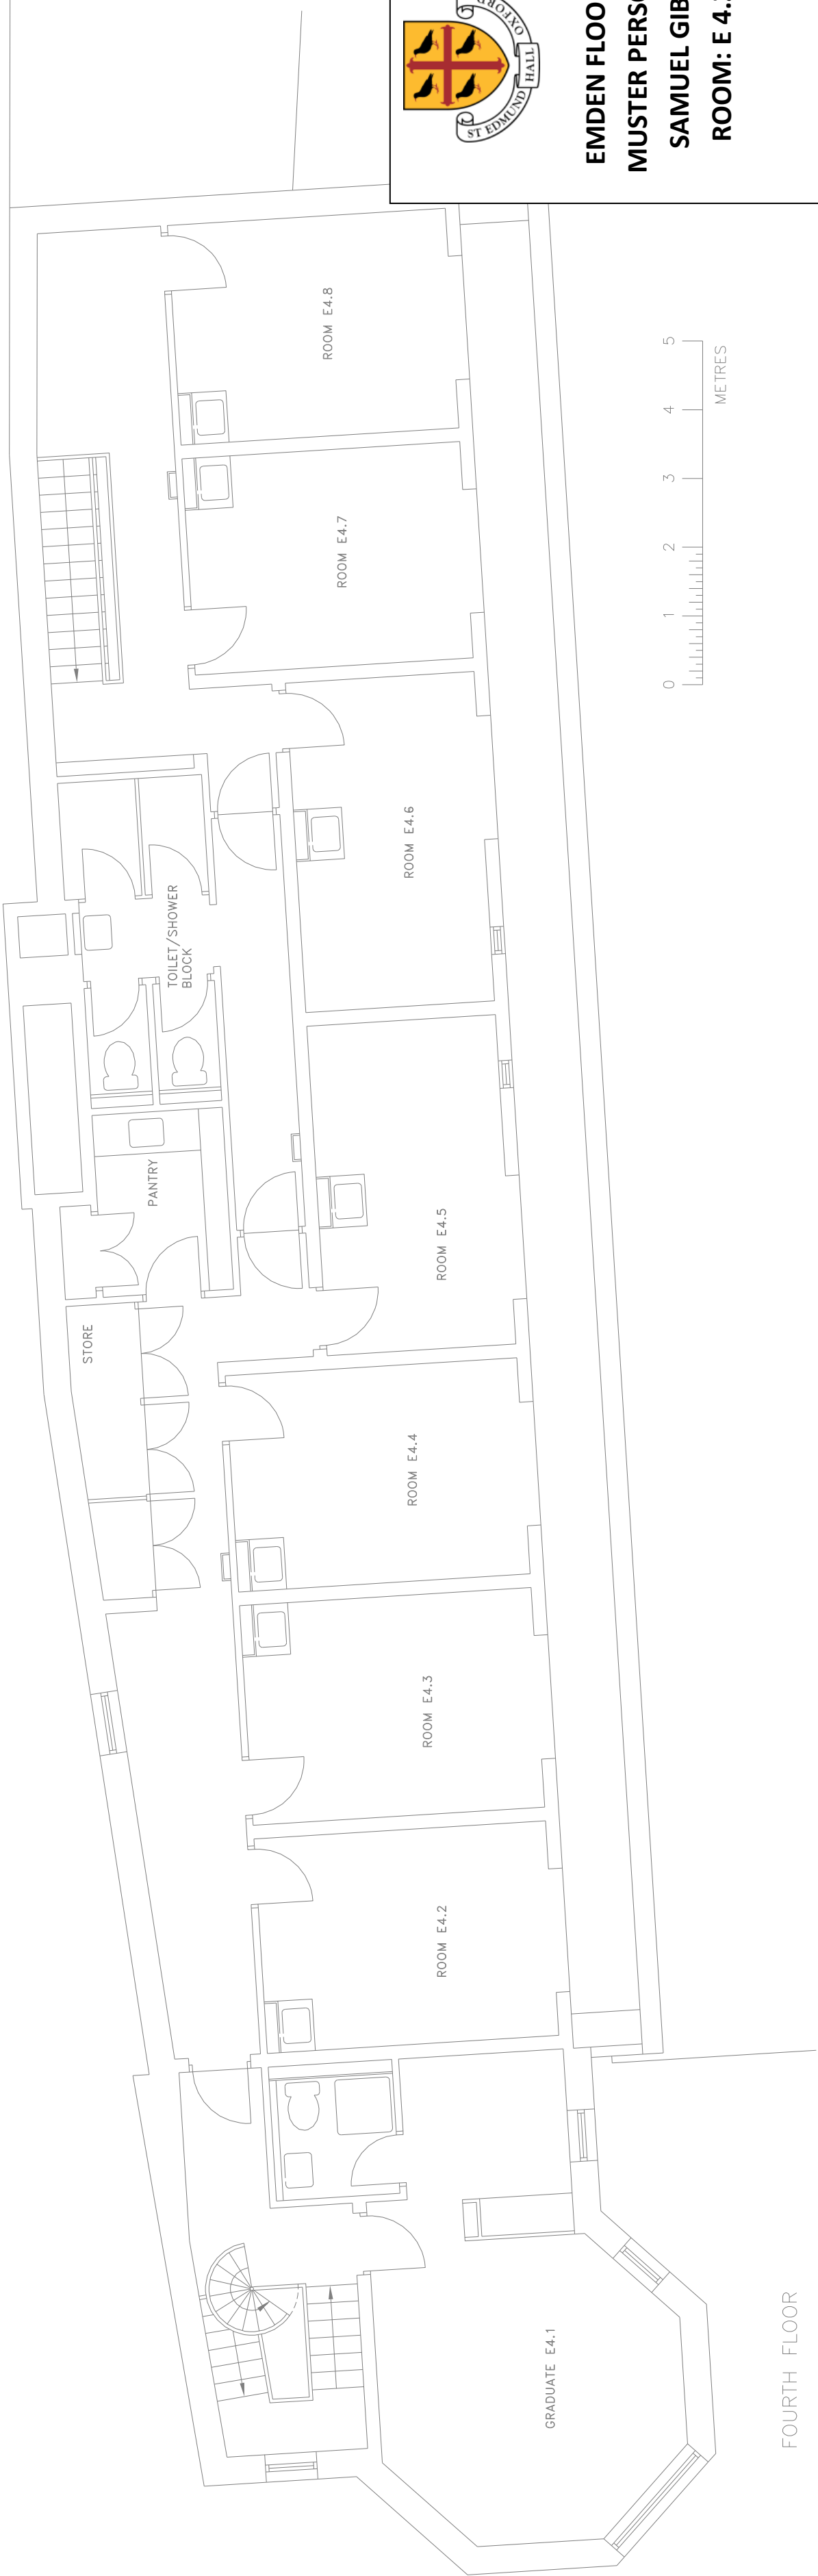

EMDEN FLOOR 4
MUSTER PERSON:
SAMUEL GIBB
ROOM: E 4.2

Date	Rev.	Description		
THIS DRAWING IS THE PROPERTY OF HAYSHAM Ltd AND MAY NOT BE COPIED WITHOUT THEIR PERMISSION				
HAYSHAM. Haysham Limited Electrical Contractors Unit 7, Glenmore Business Centre, Range Road Windish Park, Wincey, Oxfordshire, OX29 0AA Tel: 01993 774 888 Fax: 01993 778 666 Email: info@haysham.co.uk				
Date	Drawn	Appd.	Scale	A1
15/06/10	AR/Steff	AR	1:50	
Project				
St EDMUND HALL				
EMDEN BUILDING				
Title				
FOURTH FLOOR				
ELECTRICAL LAYOUT				
Drawing No.		Revision		
001949-E-505				