
 



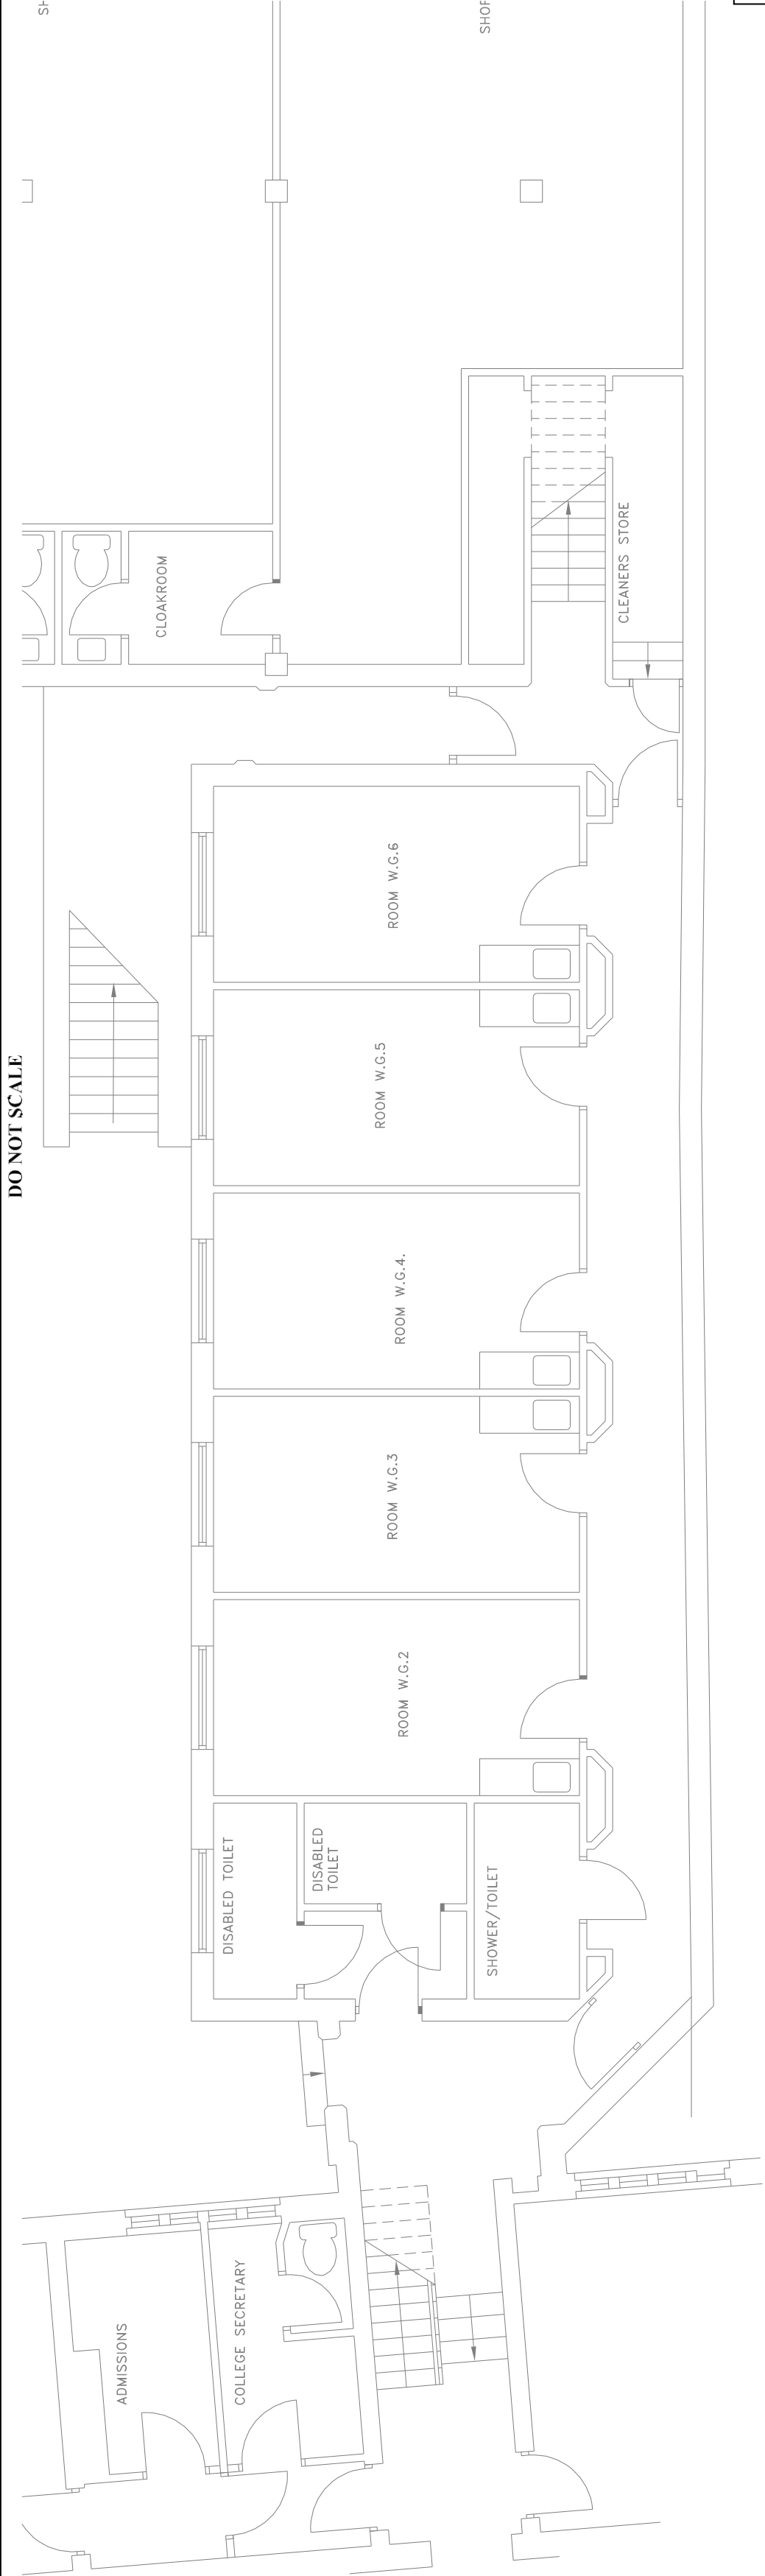

GROUND FLOOR




WHITEHALL GROUND
MUSTER PERSON:
ELLA PENNY
ROOM: WH G.3

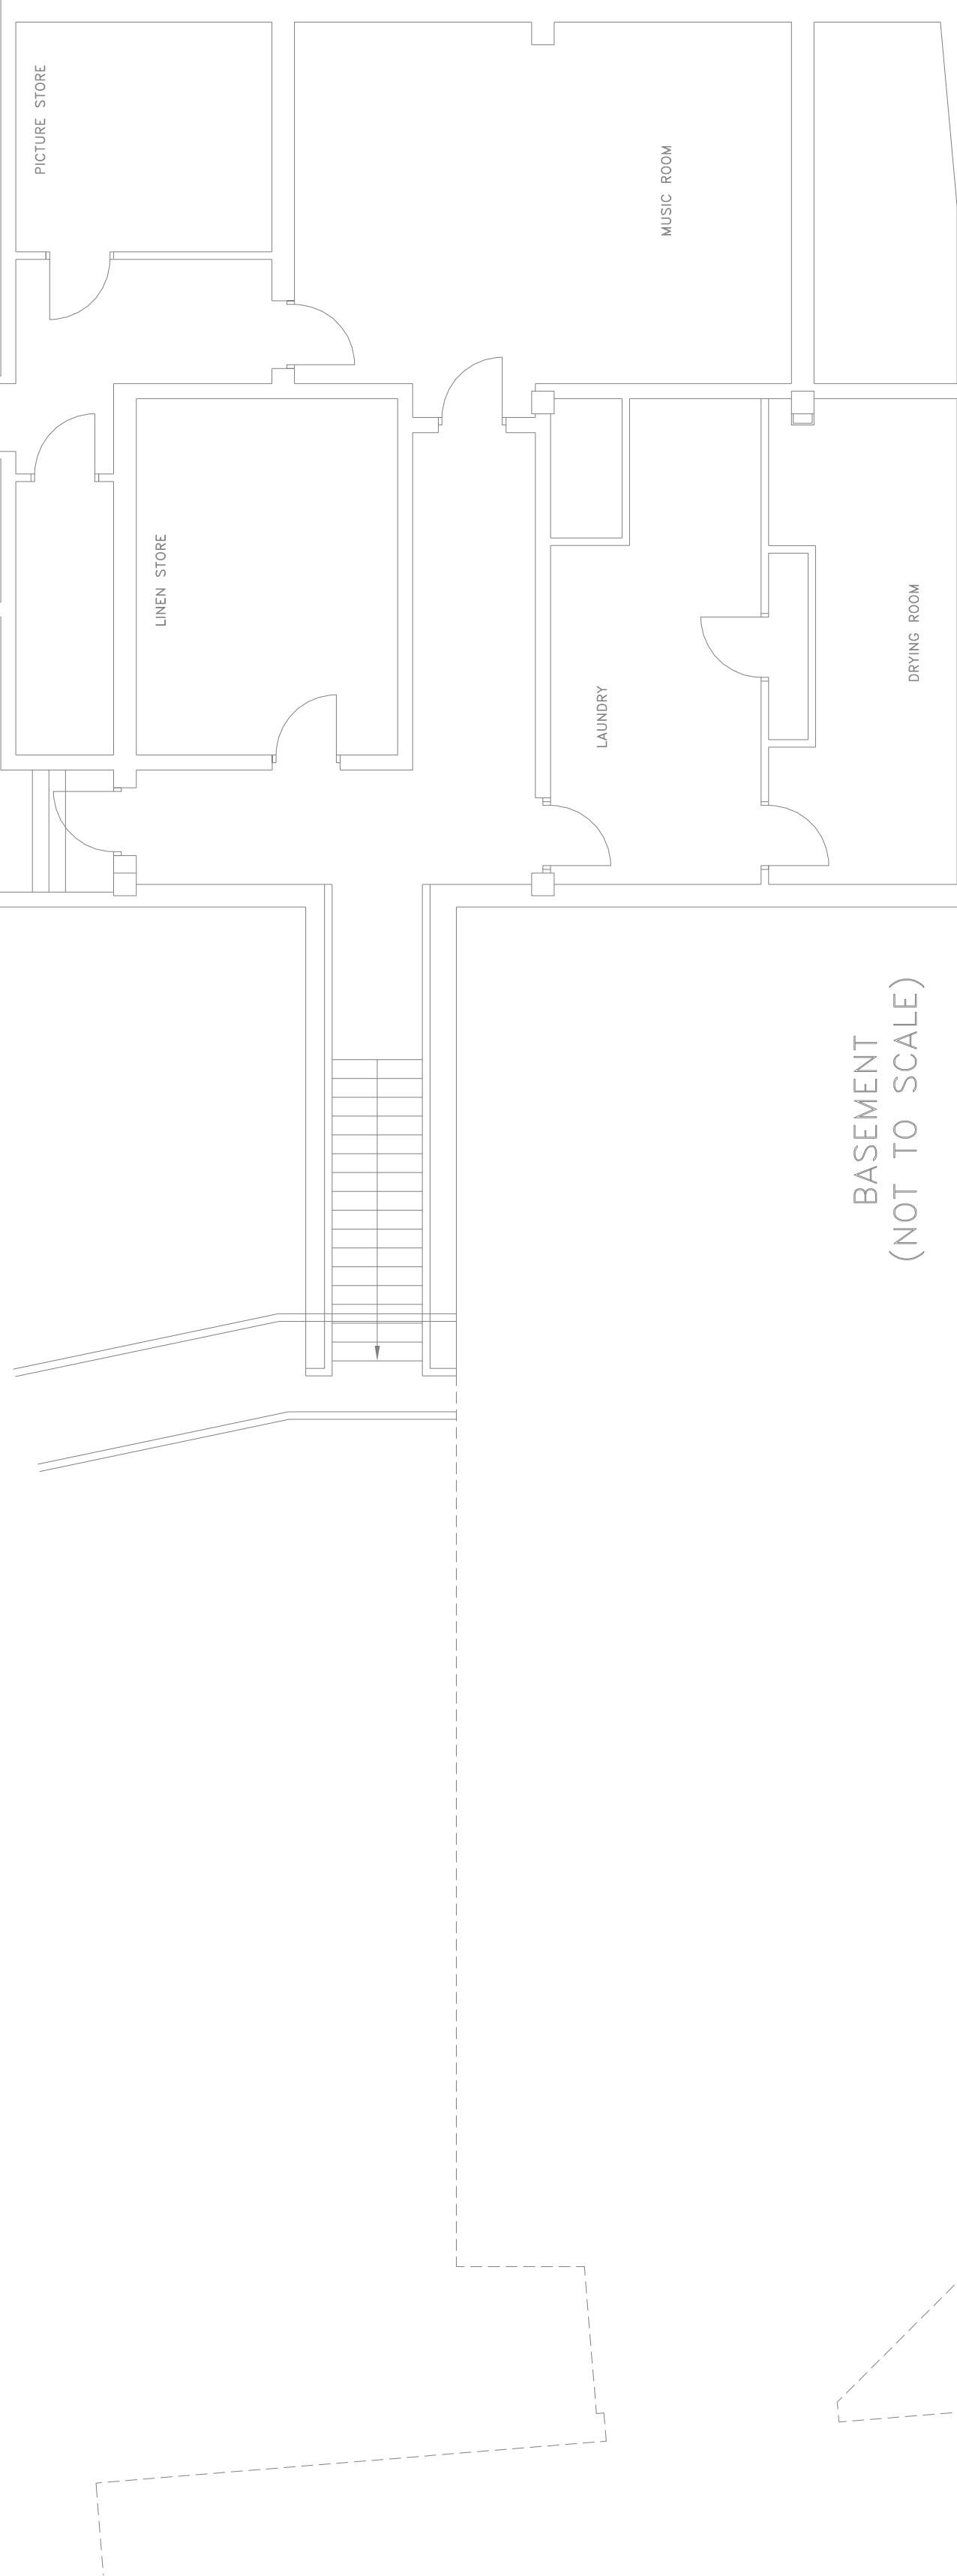


Date	Rev.	Description	
THIS DRAWING IS THE PROPERTY OF HAYSHAM LTD AND MAY NOT BE COPIED WITHOUT THEIR PERMISSION			
 Unit 7, Glenmore Business Centre, Range Road Windish Park, Wincey, Oxfordshire OX29 0AA Tel: 01993 774 888 Fax: 01993 778 666 Email: info@haysham.co.uk			
Date	Drawn	Appd.	Scale
15/06/10	AR/Steff	AR	1:50@A1
Project St EDMUND HALL WHITE HALL			
Title BASEMENT & GROUND FLOOR ELECTRICAL LAYOUT			
Drawing No.		Revision	
001949-E-101			

DO NOT SCALE

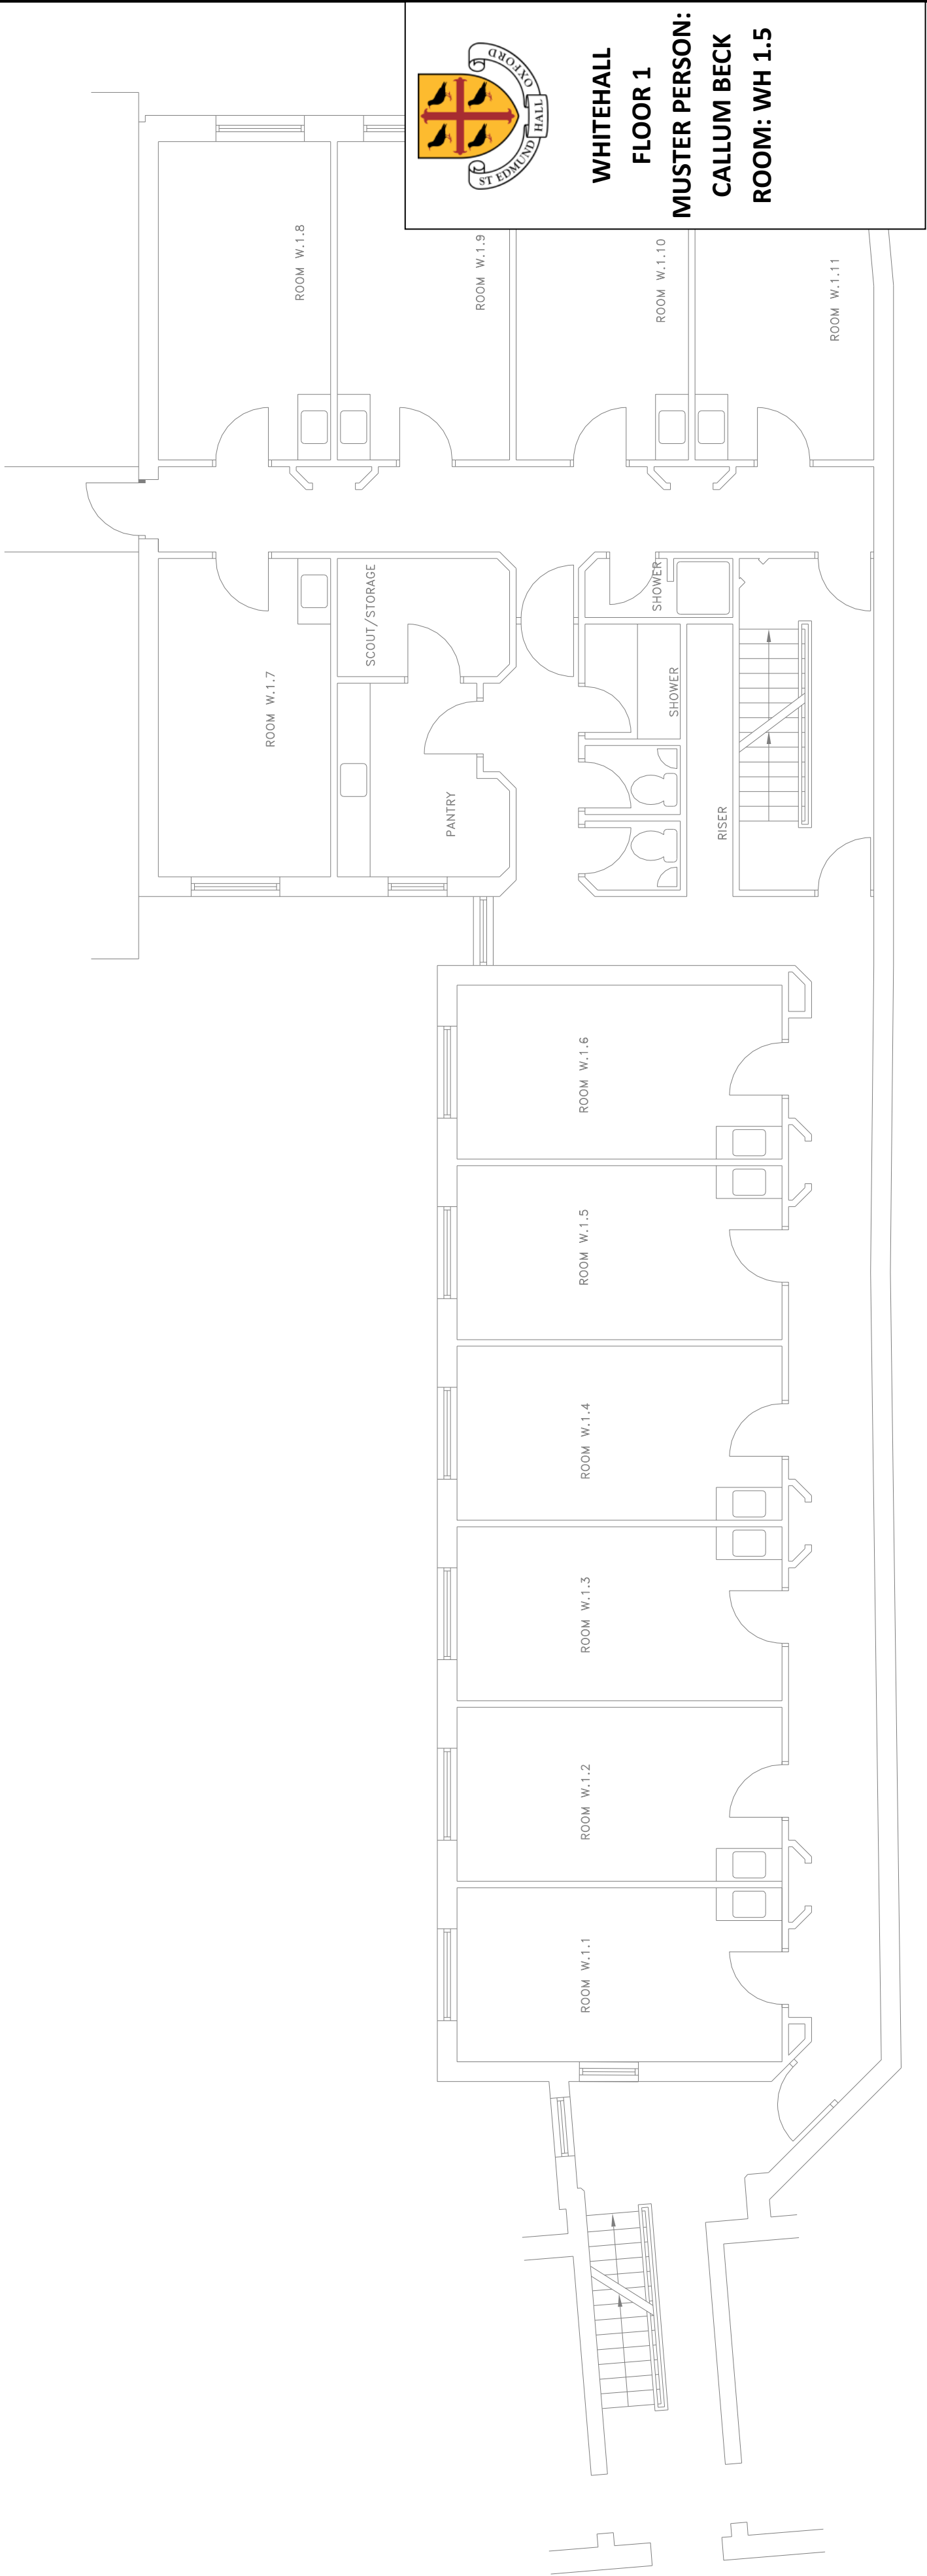


WHITE HALL
FIRST FLOOR

 

Date	Rev.	Description	
THIS DRAWING IS THE PROPERTY OF HAYSHAM Ltd AND MAY NOT BE COPIED WITHOUT THEIR PERMISSION			
HAYSHAM. Haysham Limited Electrical Contractors Unit 7, Glenmore Business Centre, Range Road Windish Park, Winsey, Oxfordshire, OX29 9AA Tel: 01993 774 888 Fax: 01993 778 666 Email: info@haysham.co.uk			
Date	Drawn	Appd.	Scale
15/06/10	AR/Steff	AR	1:50@A1
Project			
St EDMUND HALL			
WHITE HALL			
Title			
FIRST FLOOR ELECTRICAL LAYOUT			
Drawing No.		Revision	
		001949-E-102	


DO NOT SCALE

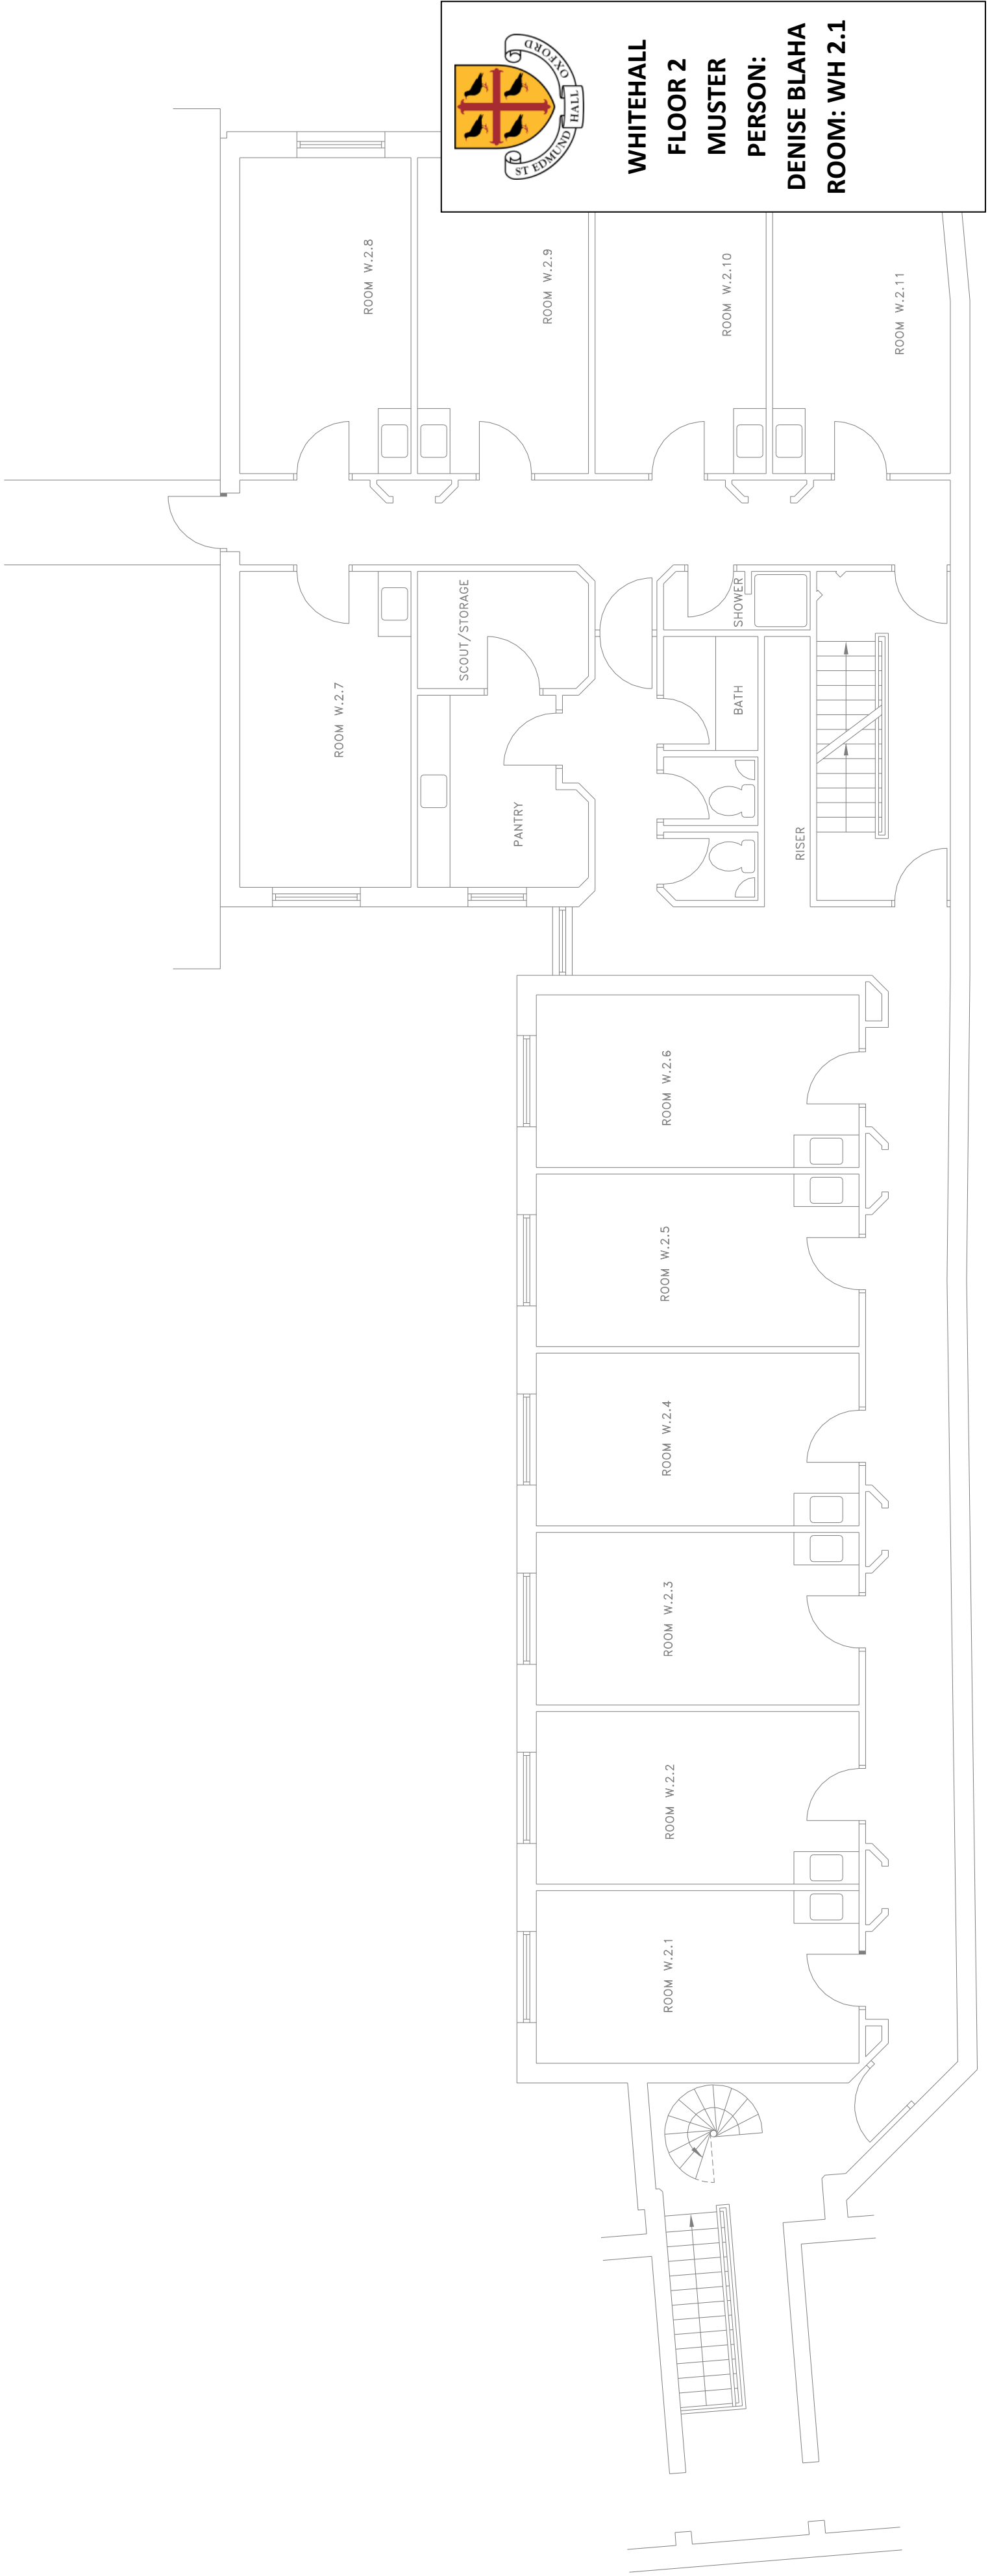

WHITE HALL
SECOND FLOOR

Date	Rev.	Description
THIS DRAWING IS THE PROPERTY OF HAYSHAM Ltd AND MAY NOT BE COPIED WITHOUT THEIR PERMISSION		
 Unit 7, Glenmore Business Centre, Range Road Windish Park, Wincey, Oxfordshire, OX29 0AA Tel: 01993 774 888 Fax: 01993 778 666 Email: info@haysham.co.uk		
Date 16/06/10	Drawn AR/Steff	Appd. AR
Scale 1:50	A1	
Project St EDMUND HALL WHITE HALL		
Title SECOND FLOOR ELECTRICAL LAYOUT		
Drawing No.		Revision
001949-E-103		

DO NOT SCALE

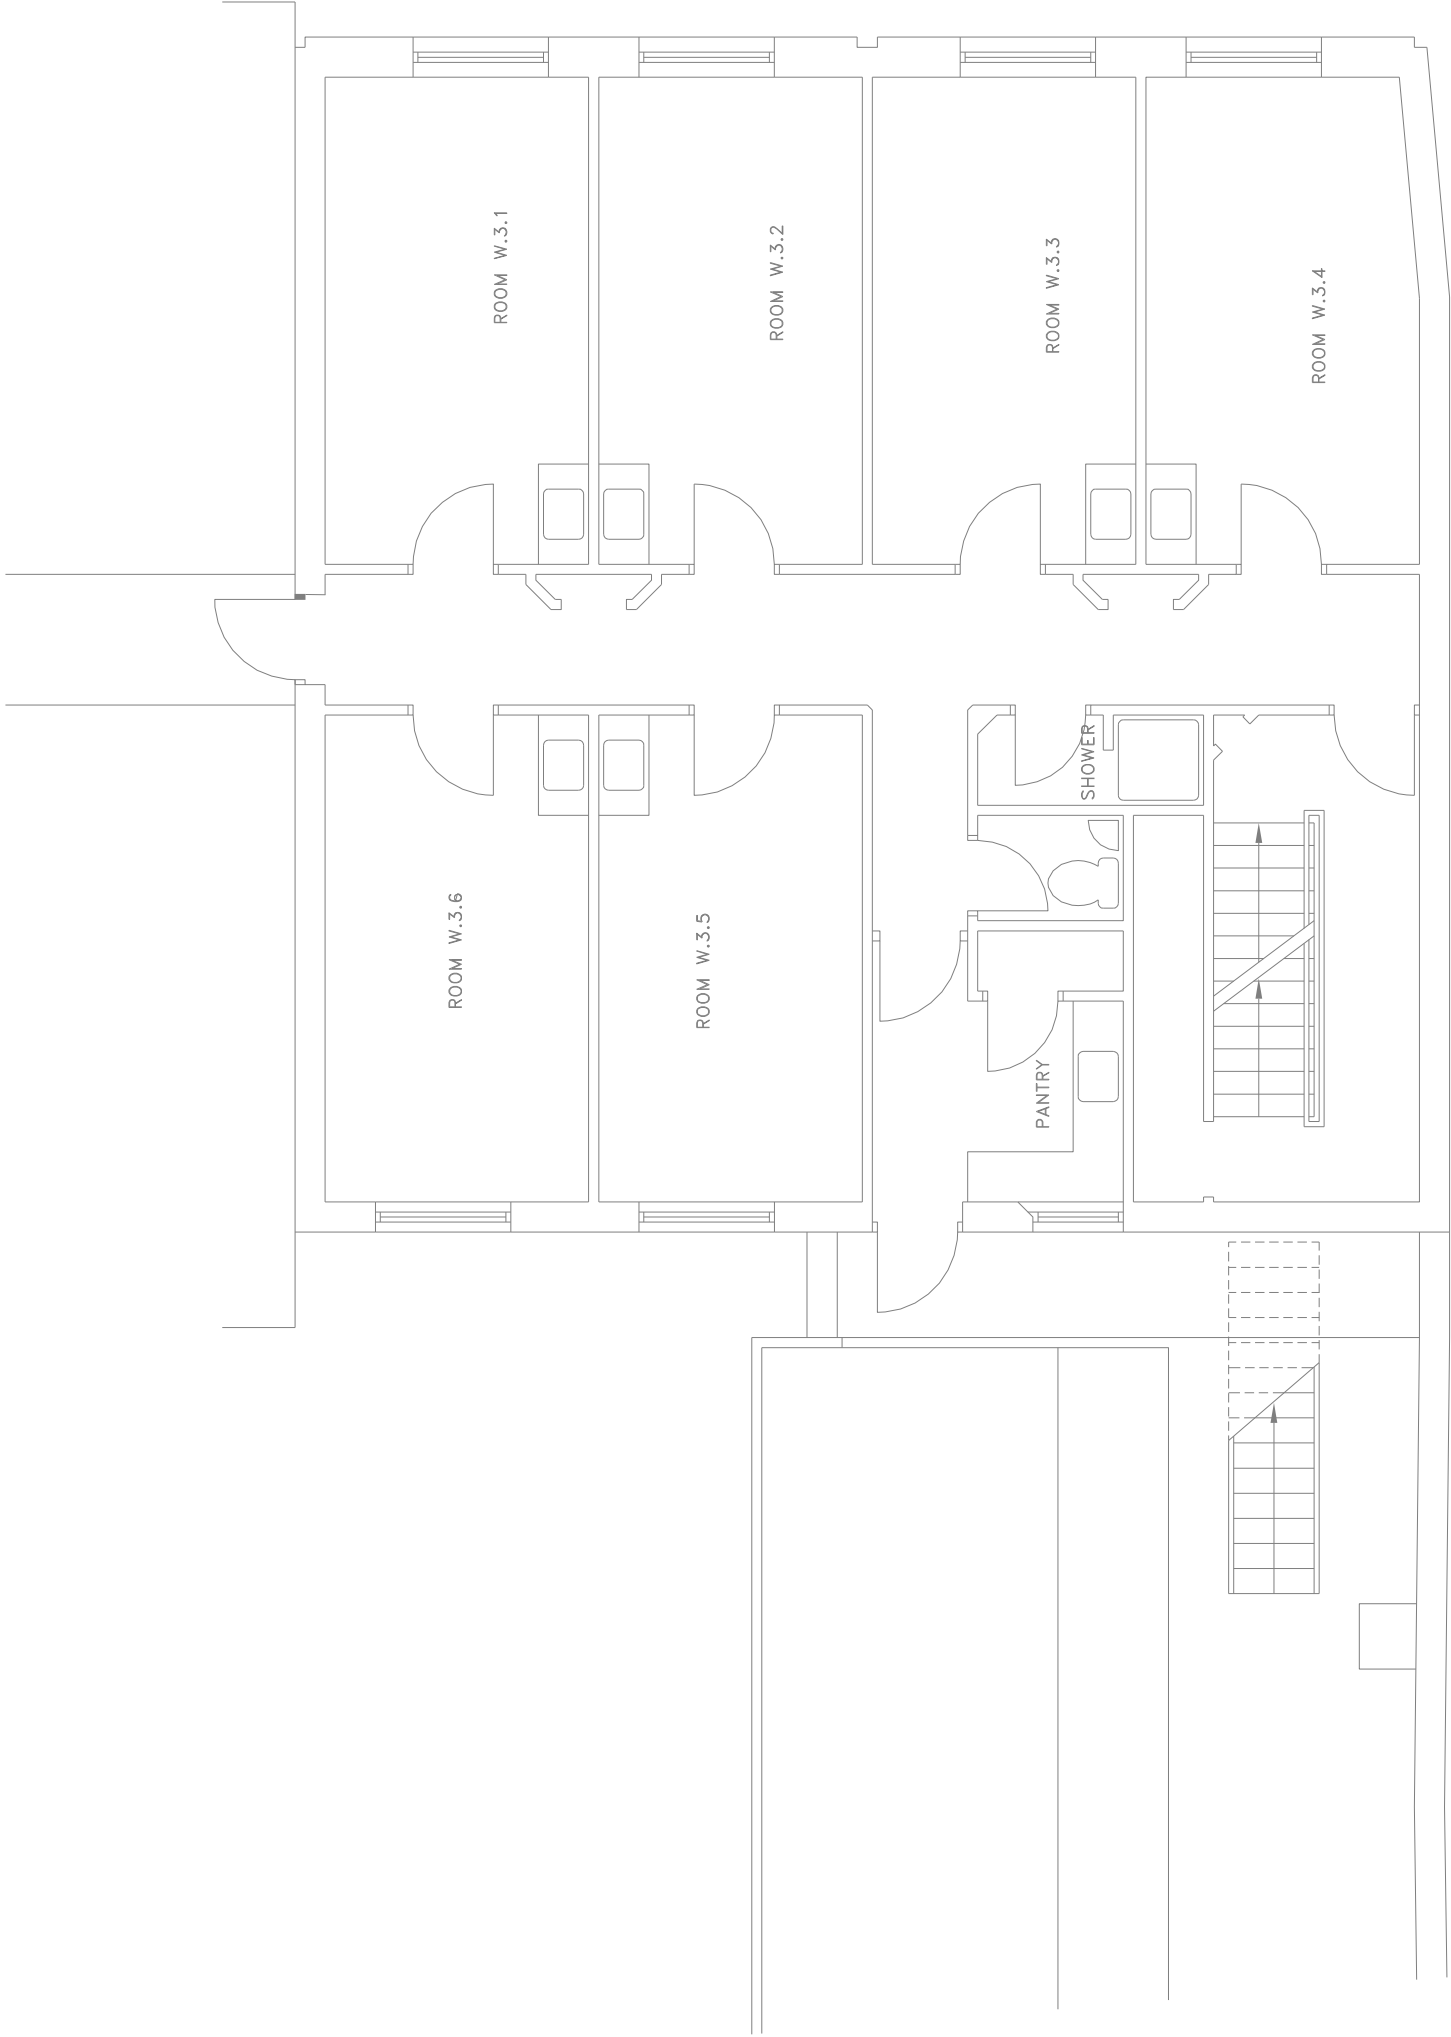



WHITEHALL

FLOOR 3

MUSTER PERSON:
CONSTANCE EYLES

ROOM: WH 3.1

Date	Rev.	Description
THIS DRAWING IS THE PROPERTY OF HAYSHAM Ltd AND MAY NOT BE COPIED WITHOUT THEIR PERMISSION		

HAYSHAM. Haysham Limited ELECTRICAL COLLABORUS Unit 7, Glenmore Business Centre, Range Road Windish Park, Winsey, Oxfordshire, OX29 0AA Tel: 01993 774 888 Fax: 01993 778 666 Email: info@haysham.co.uk		
---	--	--

Date	Drawn	Appd.	Scale
15/06/10	AR/Steff	AR	1:50@A1

Project		St EDMUND HALL WHITE HALL
Title		
THIRD FLOOR ELECTRICAL LAYOUT		

Drawing No.	Revision
001949-E-104	